



NOTES:

INDICATES A 2 HR FIRE RATED WALL. 3/8" METAL STUDS W/ (2) LAYERS TYPE X GYP. BED TO INTERIOR. (2) LAYERS 5/8" FIRE RESISTIVE GYP. SHEETING TO EXTERIOR. W/ FRIGID INSULATION, 1" AIR SPACE AND 4" LIMESTONE PANEL. EXTEND GYP. BED AND SHEETING TO ROOF DECK ABOVE. SEE WALL SECTION BELOW.

INDICATES 1 HR FIRE RATED WALL. METAL STUDS W/ (1) LAYER 5/8" TYPE X GYP. BED TO BOTH SIDES. EXTEND TO ROOF DECK ABOVE. BRICK, VERBIC AND LIMESTONE WALL TO RECEIVE (1) LAYER 5/8" TYPE X GYP. BED TO INTERIOR AND (2) LAYER 5/8" FIRE RESISTIVE GYP. SHEETING TO EXTERIOR. SEE WALL SECTIONS A3, A4 AND A5.

INDICATES 2' x 2' LIGHT FIXTURE.

INDICATES LINEAR LIGHT FIXTURE.


BOTH INDICATE AIR SUPPLY DIFFUSER.

INDICATES RETURN AIR GRILL.


INDICATES PANLIGHT.

GENERAL NOTE:
LIGHT FIXTURES AND MECHANICAL GRILLS INDICATED ON REFLECTED CEILING PLAN THIS SHEET FOR LOCATION PURPOSES ONLY. FOR TYPE SIZE SEE MECHANICAL. NOT ALL FIXTURES SHOWN ON THIS PLAN.

INDICATES 4' x 4' CEILING GRID (15'-0" AFF) SEE SPECIFICATIONS. EXTENDS UNDER ENTIRE 20'-0" CEILING.

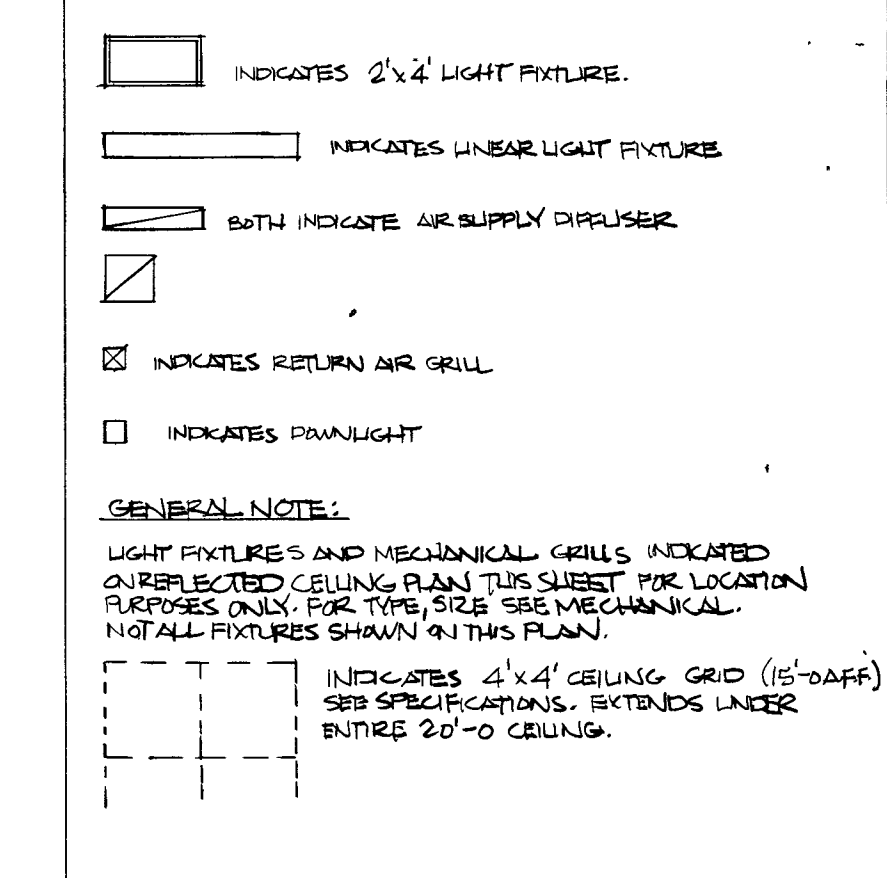

**NEW FACILITY FOR
BLUFFTON -
WELLS COUNTY
PUBLIC LIBRARY
BLUFFTON, INDIANA 46714**

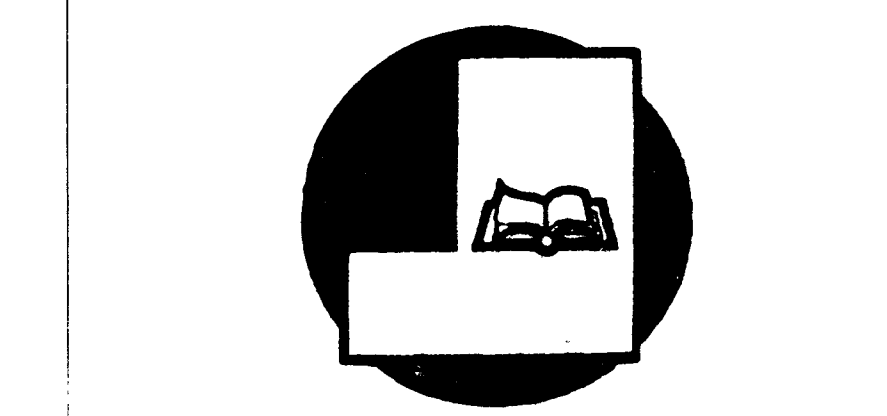


SHEET TITLE:
REFLECTIVE CEILING PLAN

PROJECT NO. 88-1207 REVISIONS: SHEET NO. A6.1
DATE: 6-20-90



REFLECTED CEILING PLAN
SCALE: 1/8" = 1'-0"

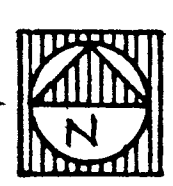

1111
5222
333
444
555
666
777
888
999
000

T 1.
B
G
A6.1 a
A6.1 b
c