


NOTES:

**NEW FACILITY FOR
BLUFFTON -
WELLS COUNTY
PUBLIC LIBRARY**
BLUFFTON, INDIANA 46714

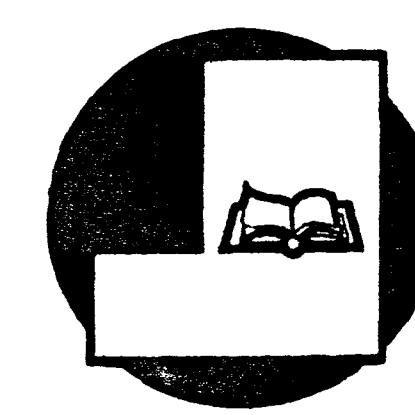

SHEET TITLE :


FOUNDATION PLAN

PROJECT NO.
88-1207
DATE :
6-20-90

REVISIONS :


SHEET NO.

S2.1

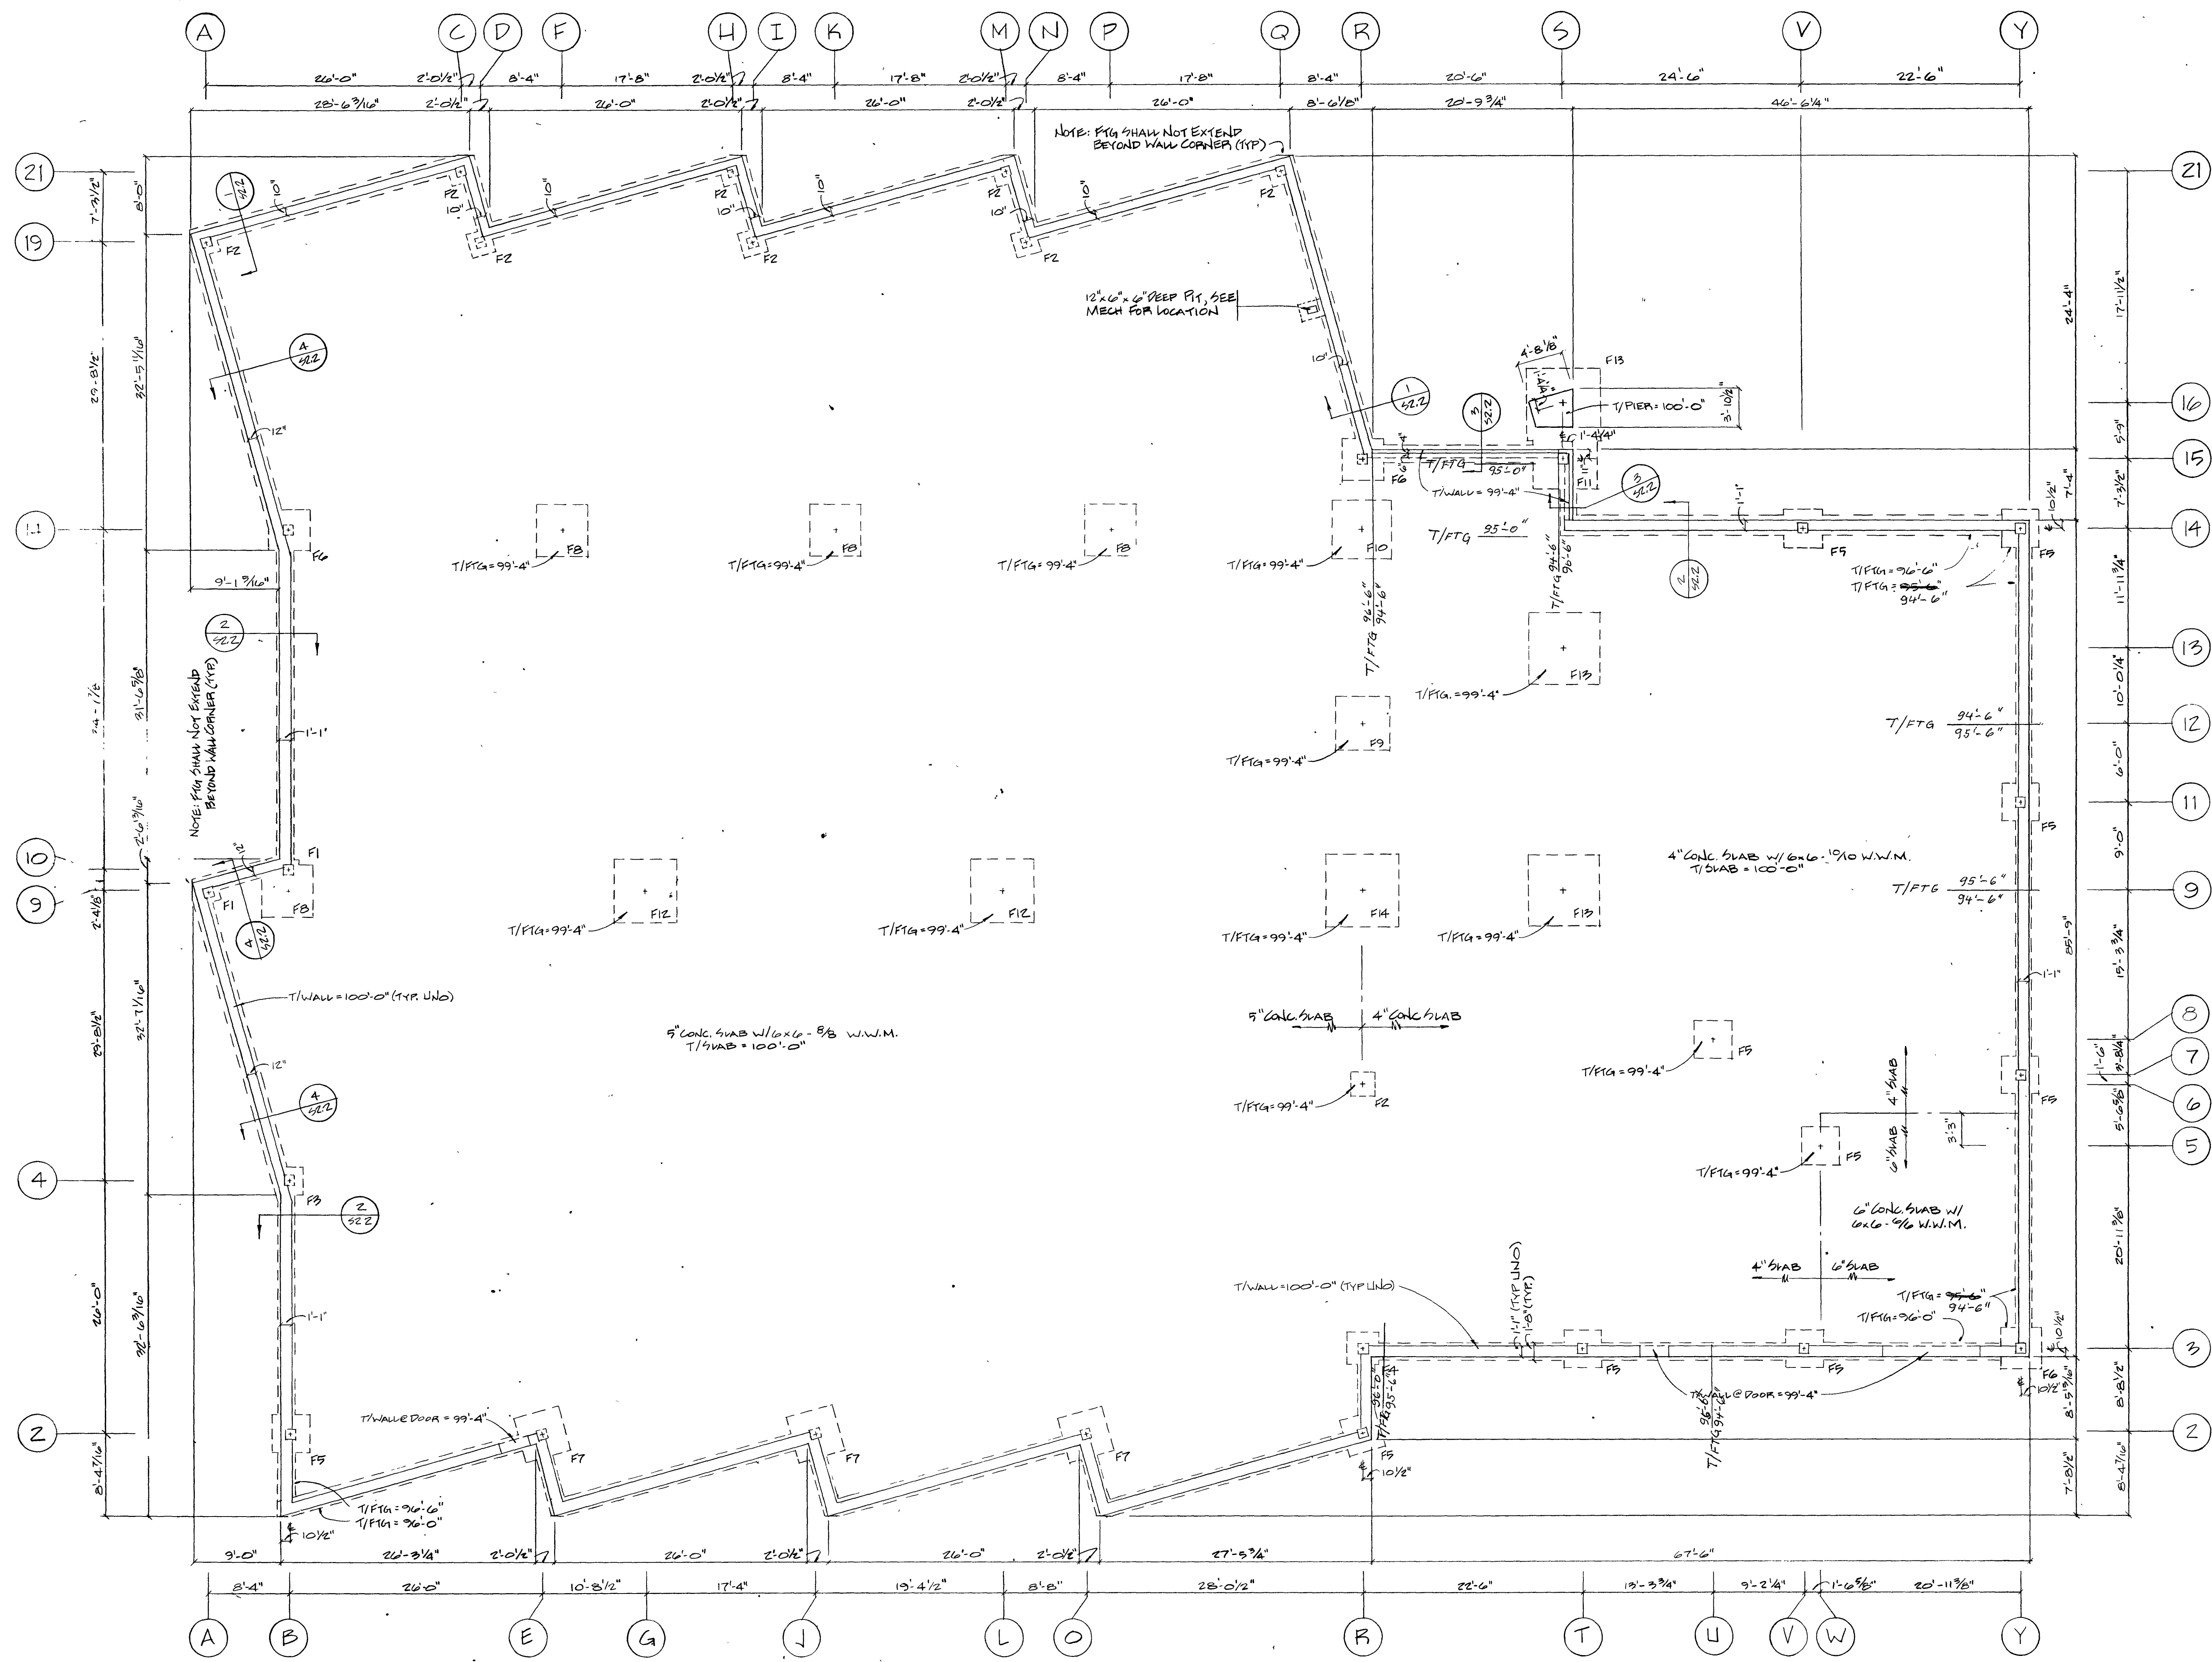

NOTES:
1. G.C. TO POUR AROUND TRENCH DUCTS, SEE ELECTRICAL
2. SEE SHEET 22.2 FOR TYP. THICKENED SLAB DETAIL.

Foundation Plan

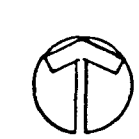

1111
5222
333
444
555
666
777
888
999
000

T
B
G
a
b
c