


NOTES:

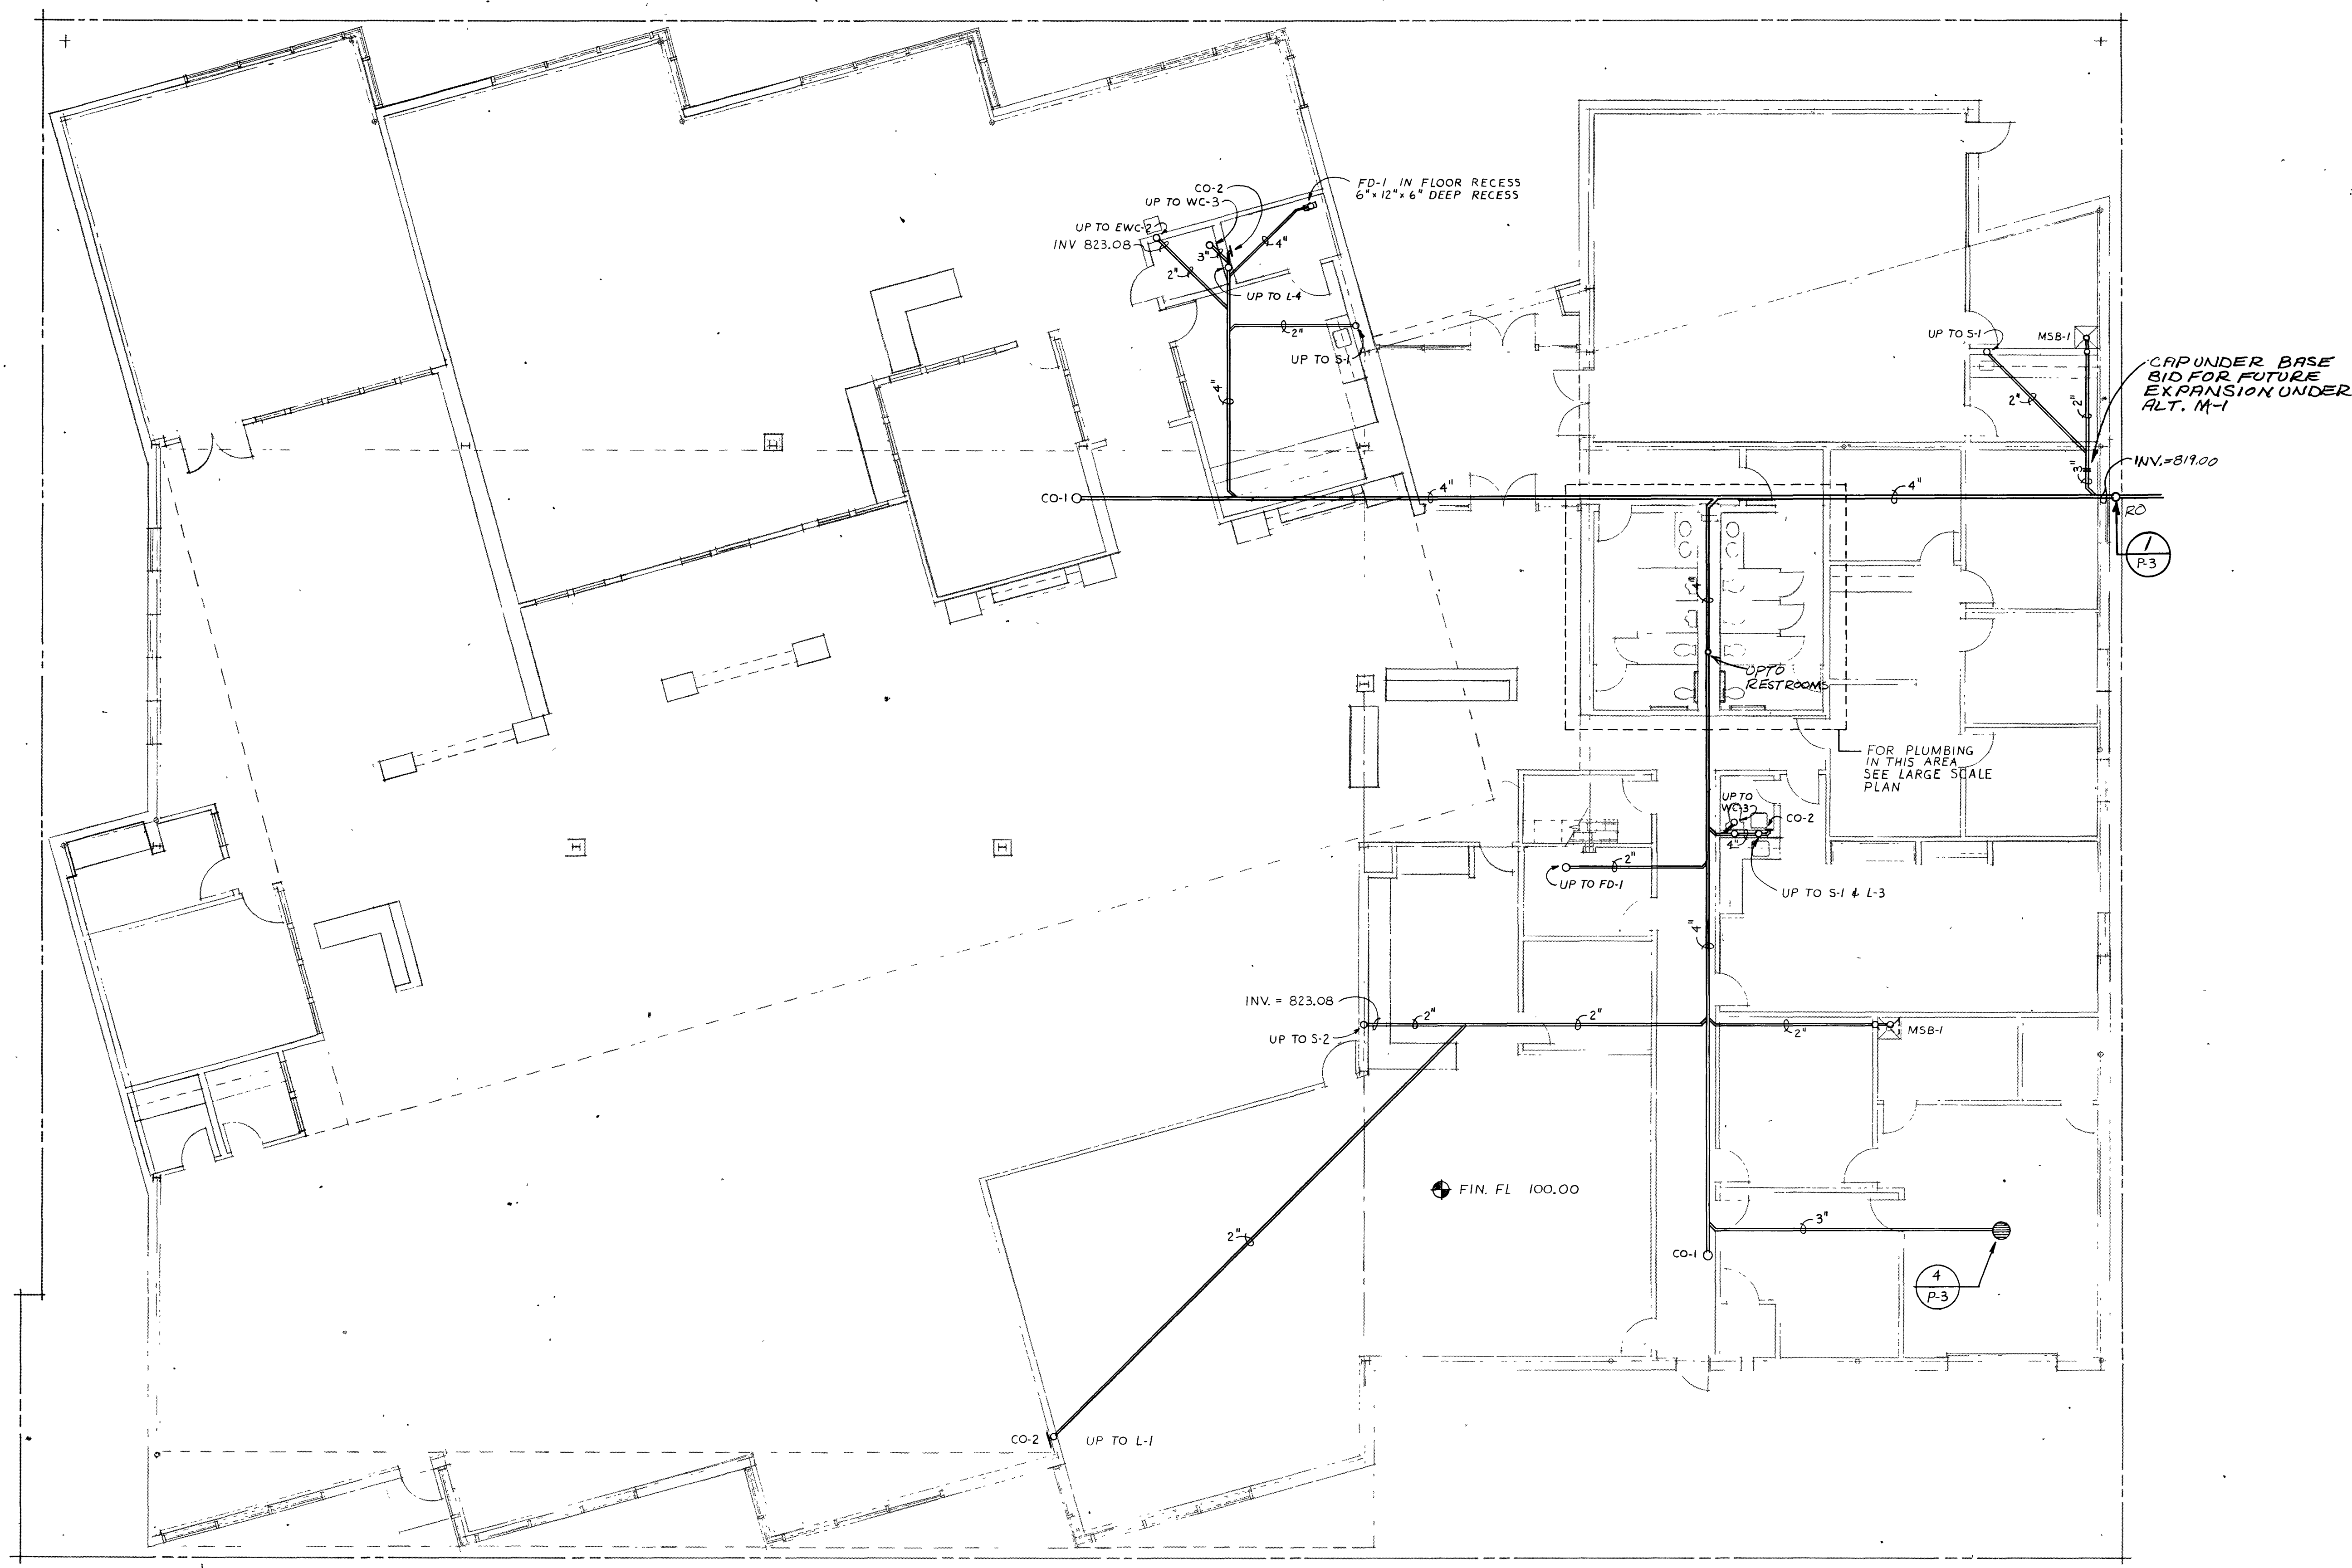


1111
5222
333
444
555
666
777
888
999
000

T 1
B
G
a
b
c

BELOW FLOOR PLUMBING PLAN SCALE 1/8"=1'-0"

**NEW FACILITY FOR
BLUFFTON -
WELLS COUNTY
PUBLIC LIBRARY**
BLUFFTON, INDIANA 46714

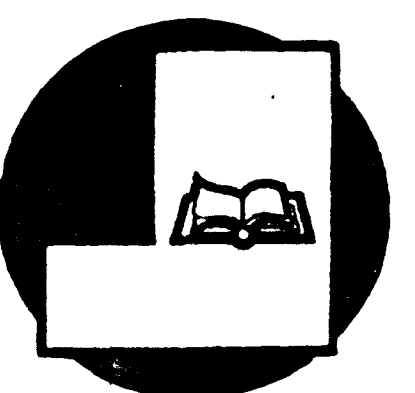

SHEET TITLE :		
PLUMBING PLAN BELOW FLOOR		
PROJECT NO. 88-1207	REVISIONS :	SHEET NO. P-1
DATE : 6-20-90		