



NOTES:

**NEW FACILITY FOR
BLUFFTON -
WELLS COUNTY
PUBLIC LIBRARY**
BLUFFTON, INDIANA 46714

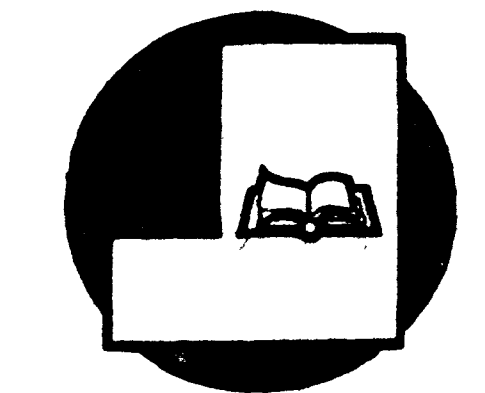

SHEET TITLE:
HVAC PLAN

PROJECT NO. 88-1207 REVISIONS: DATE: 6-20-90 SHEET NO. **M-1**

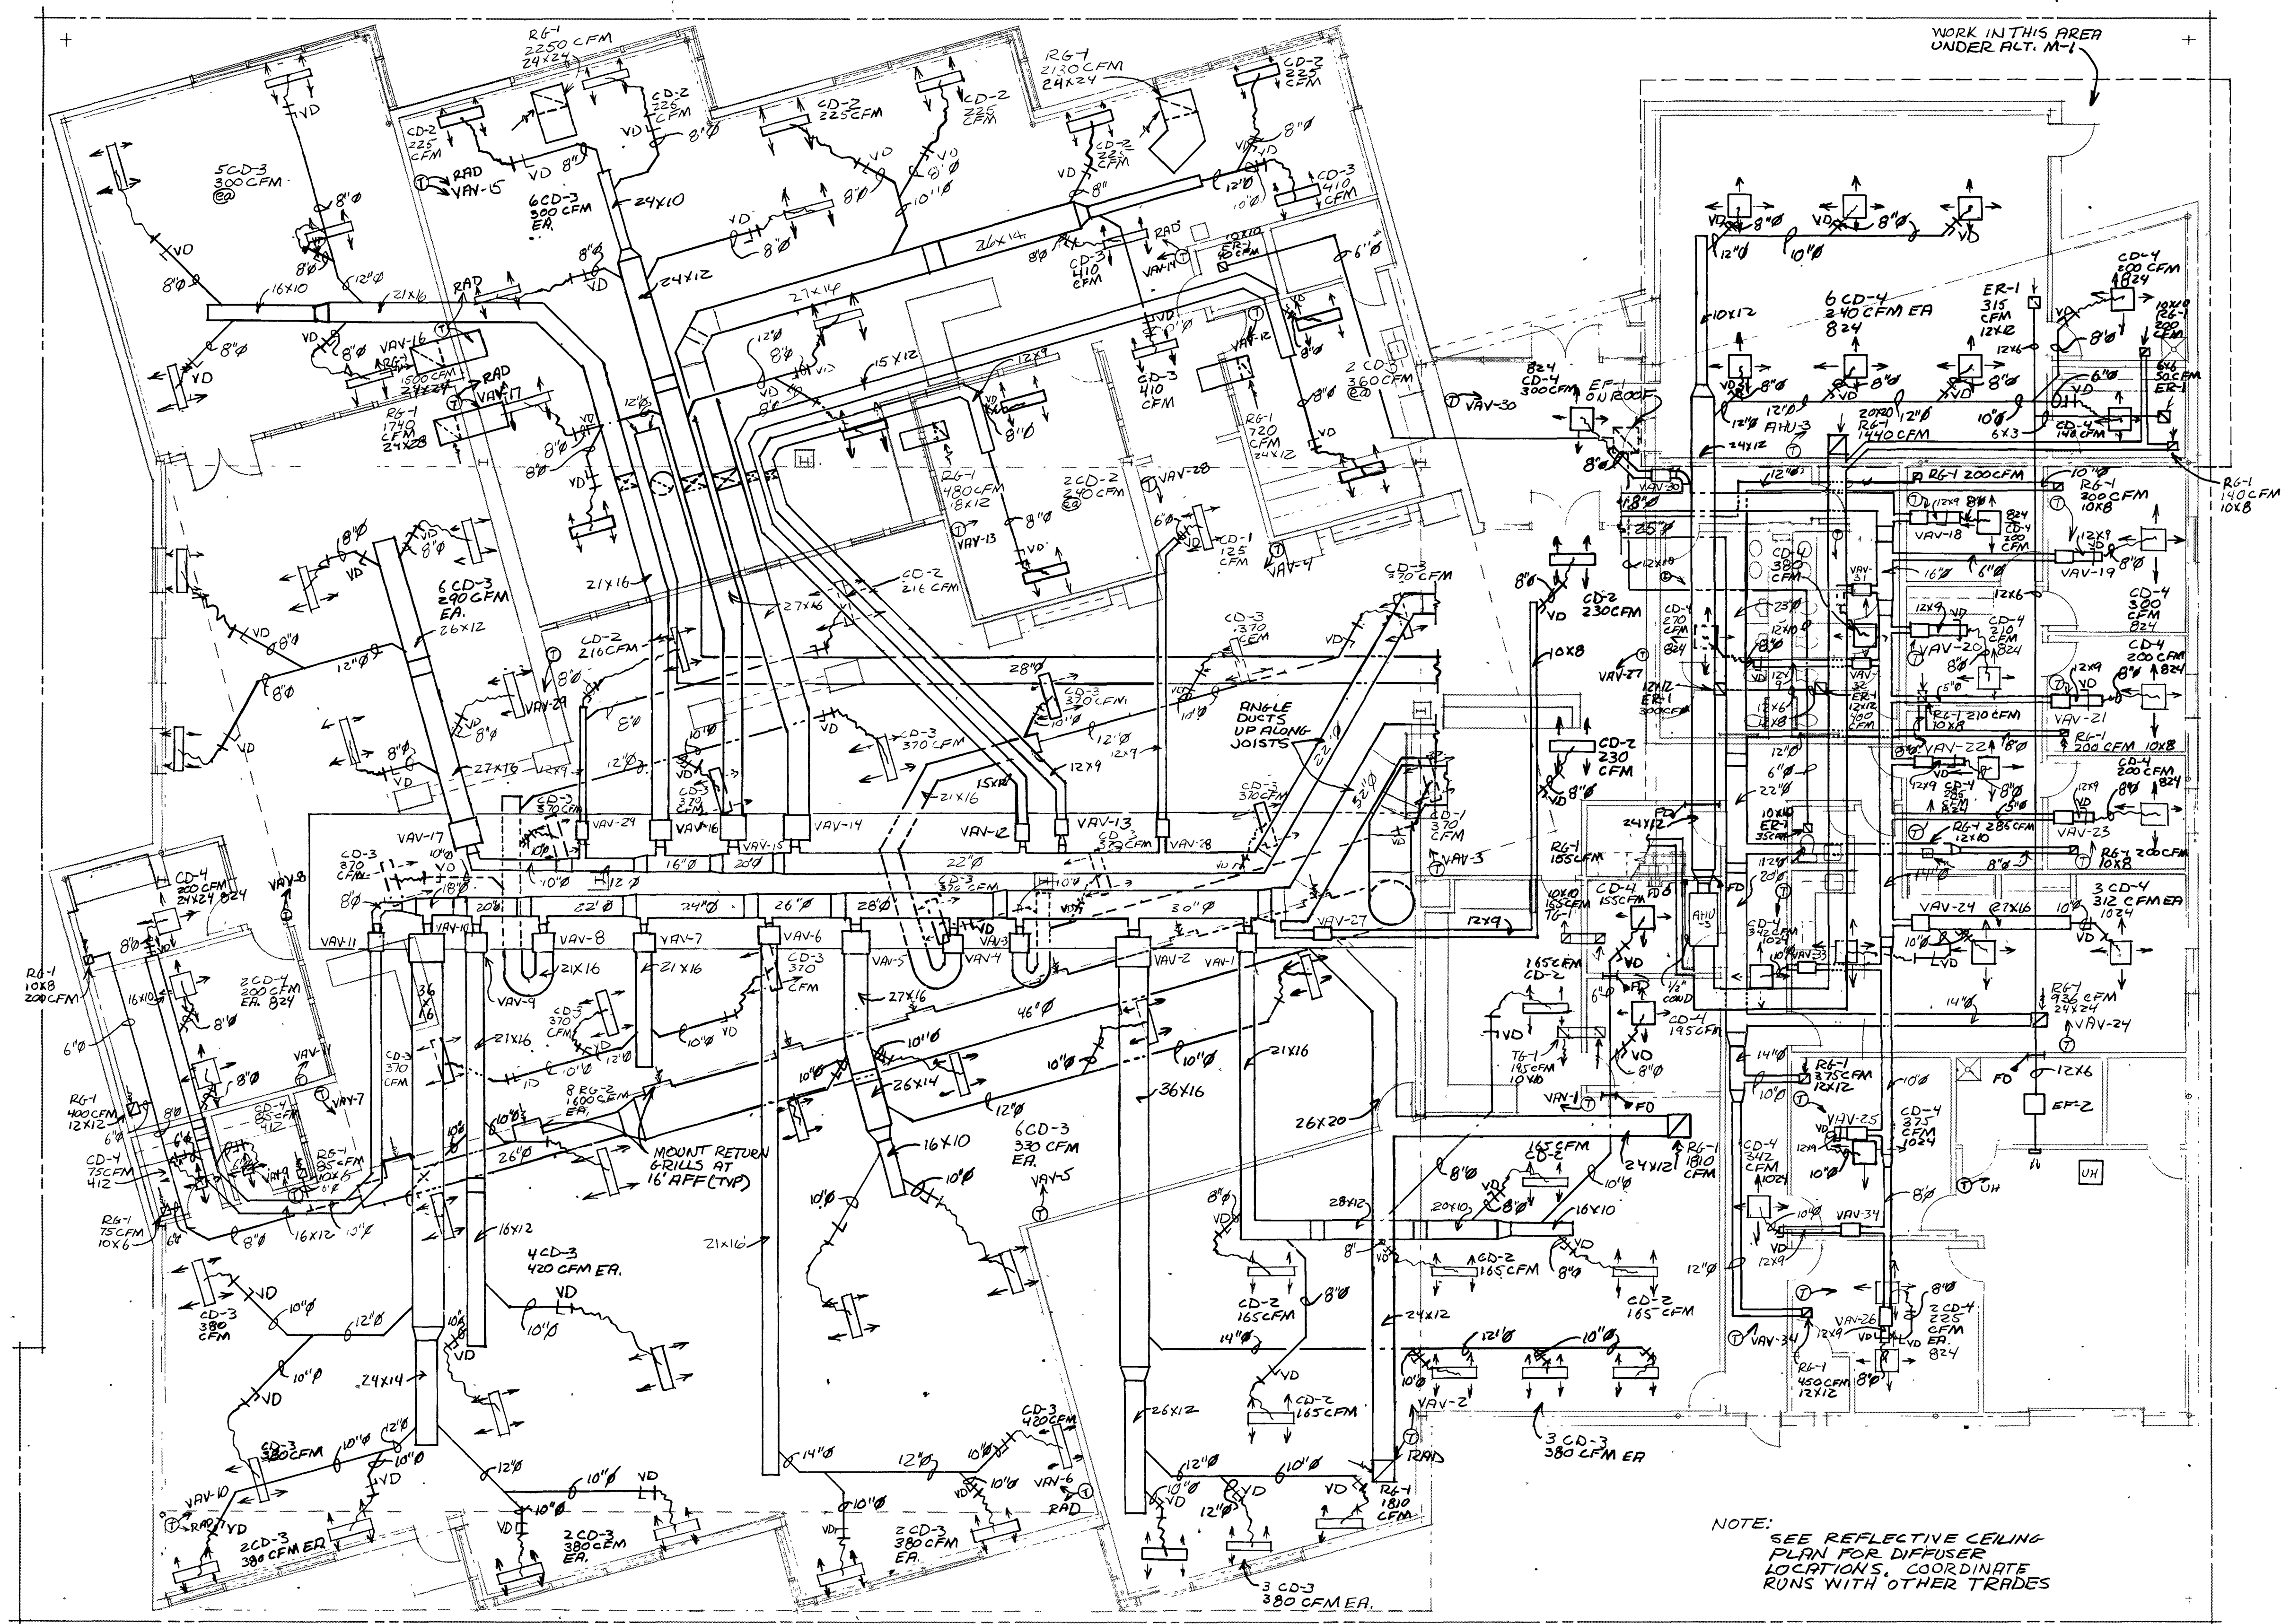

1111
5222
333
444
555
666
777
888
999
000

T 1
B
G
a
b
c

HVAC PLAN SCALE 1/8"=1'-0"