




Donald D. Helmecki

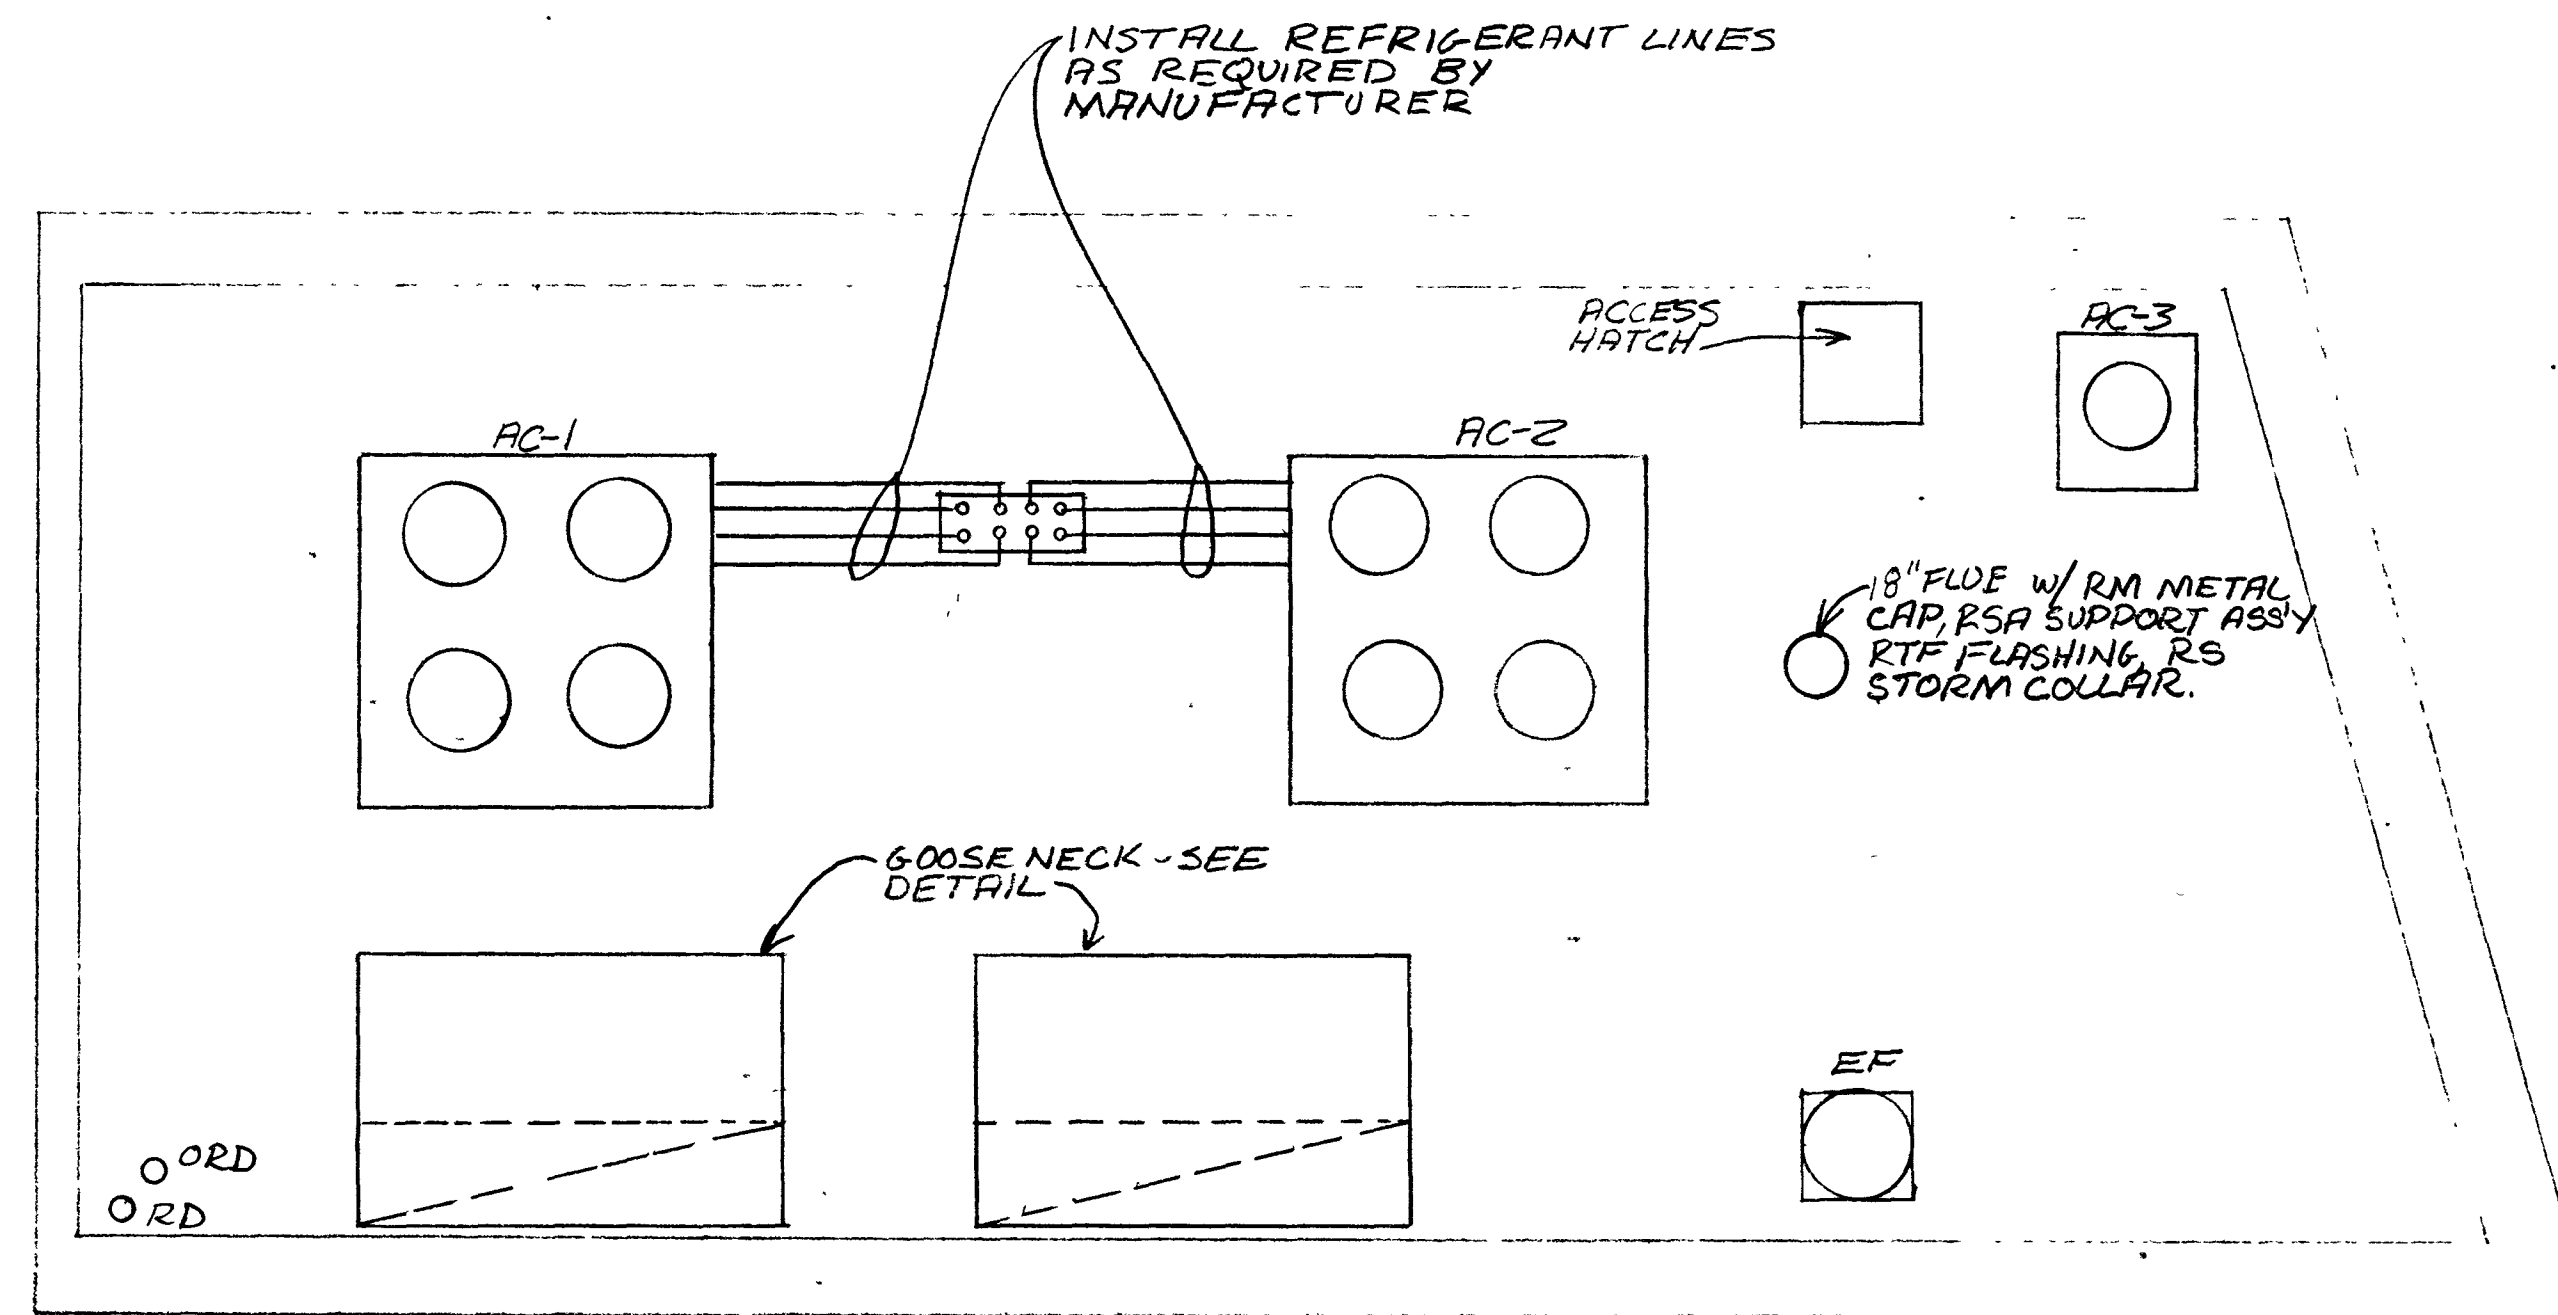


MECHANICAL ROOM ROOF PLAN SCALE 1/4"=1'-0"


NOTES:

1111
5222
333
444
555
666
777
888
999
000

(1)
B
G
a
b
c

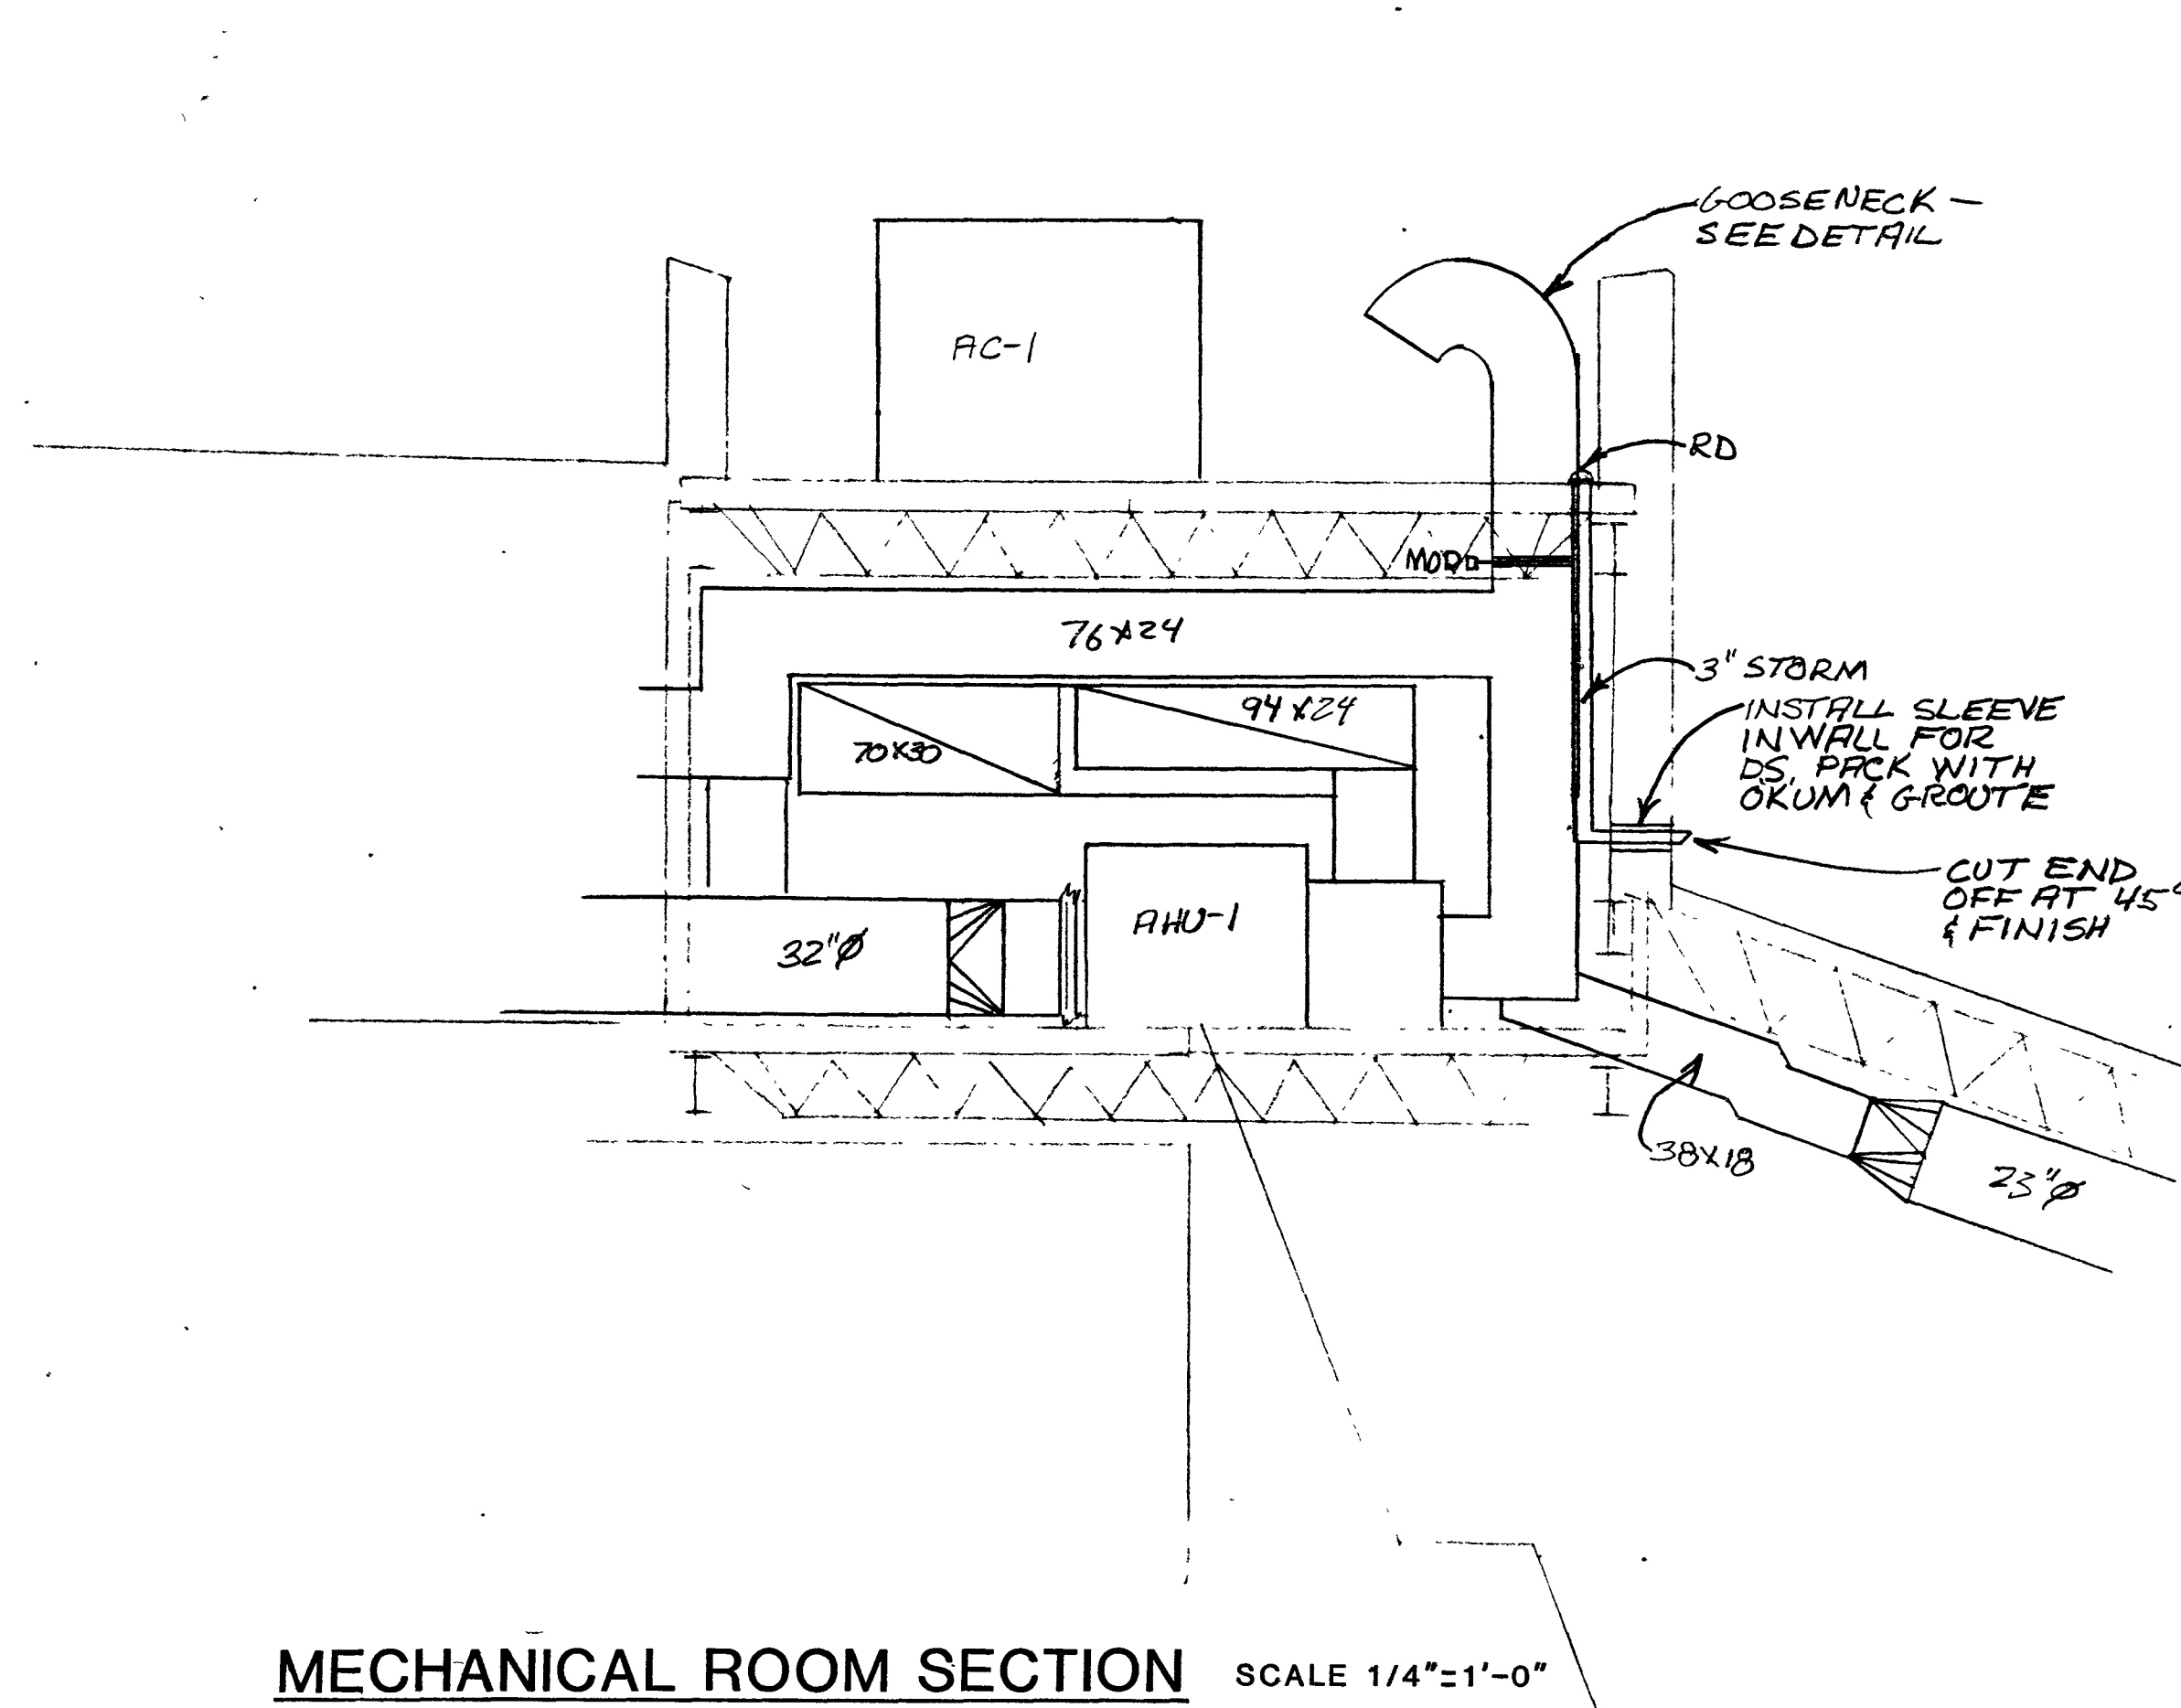


MECHANICAL ROOM SECTION SCALE 1/4"=1'-0"

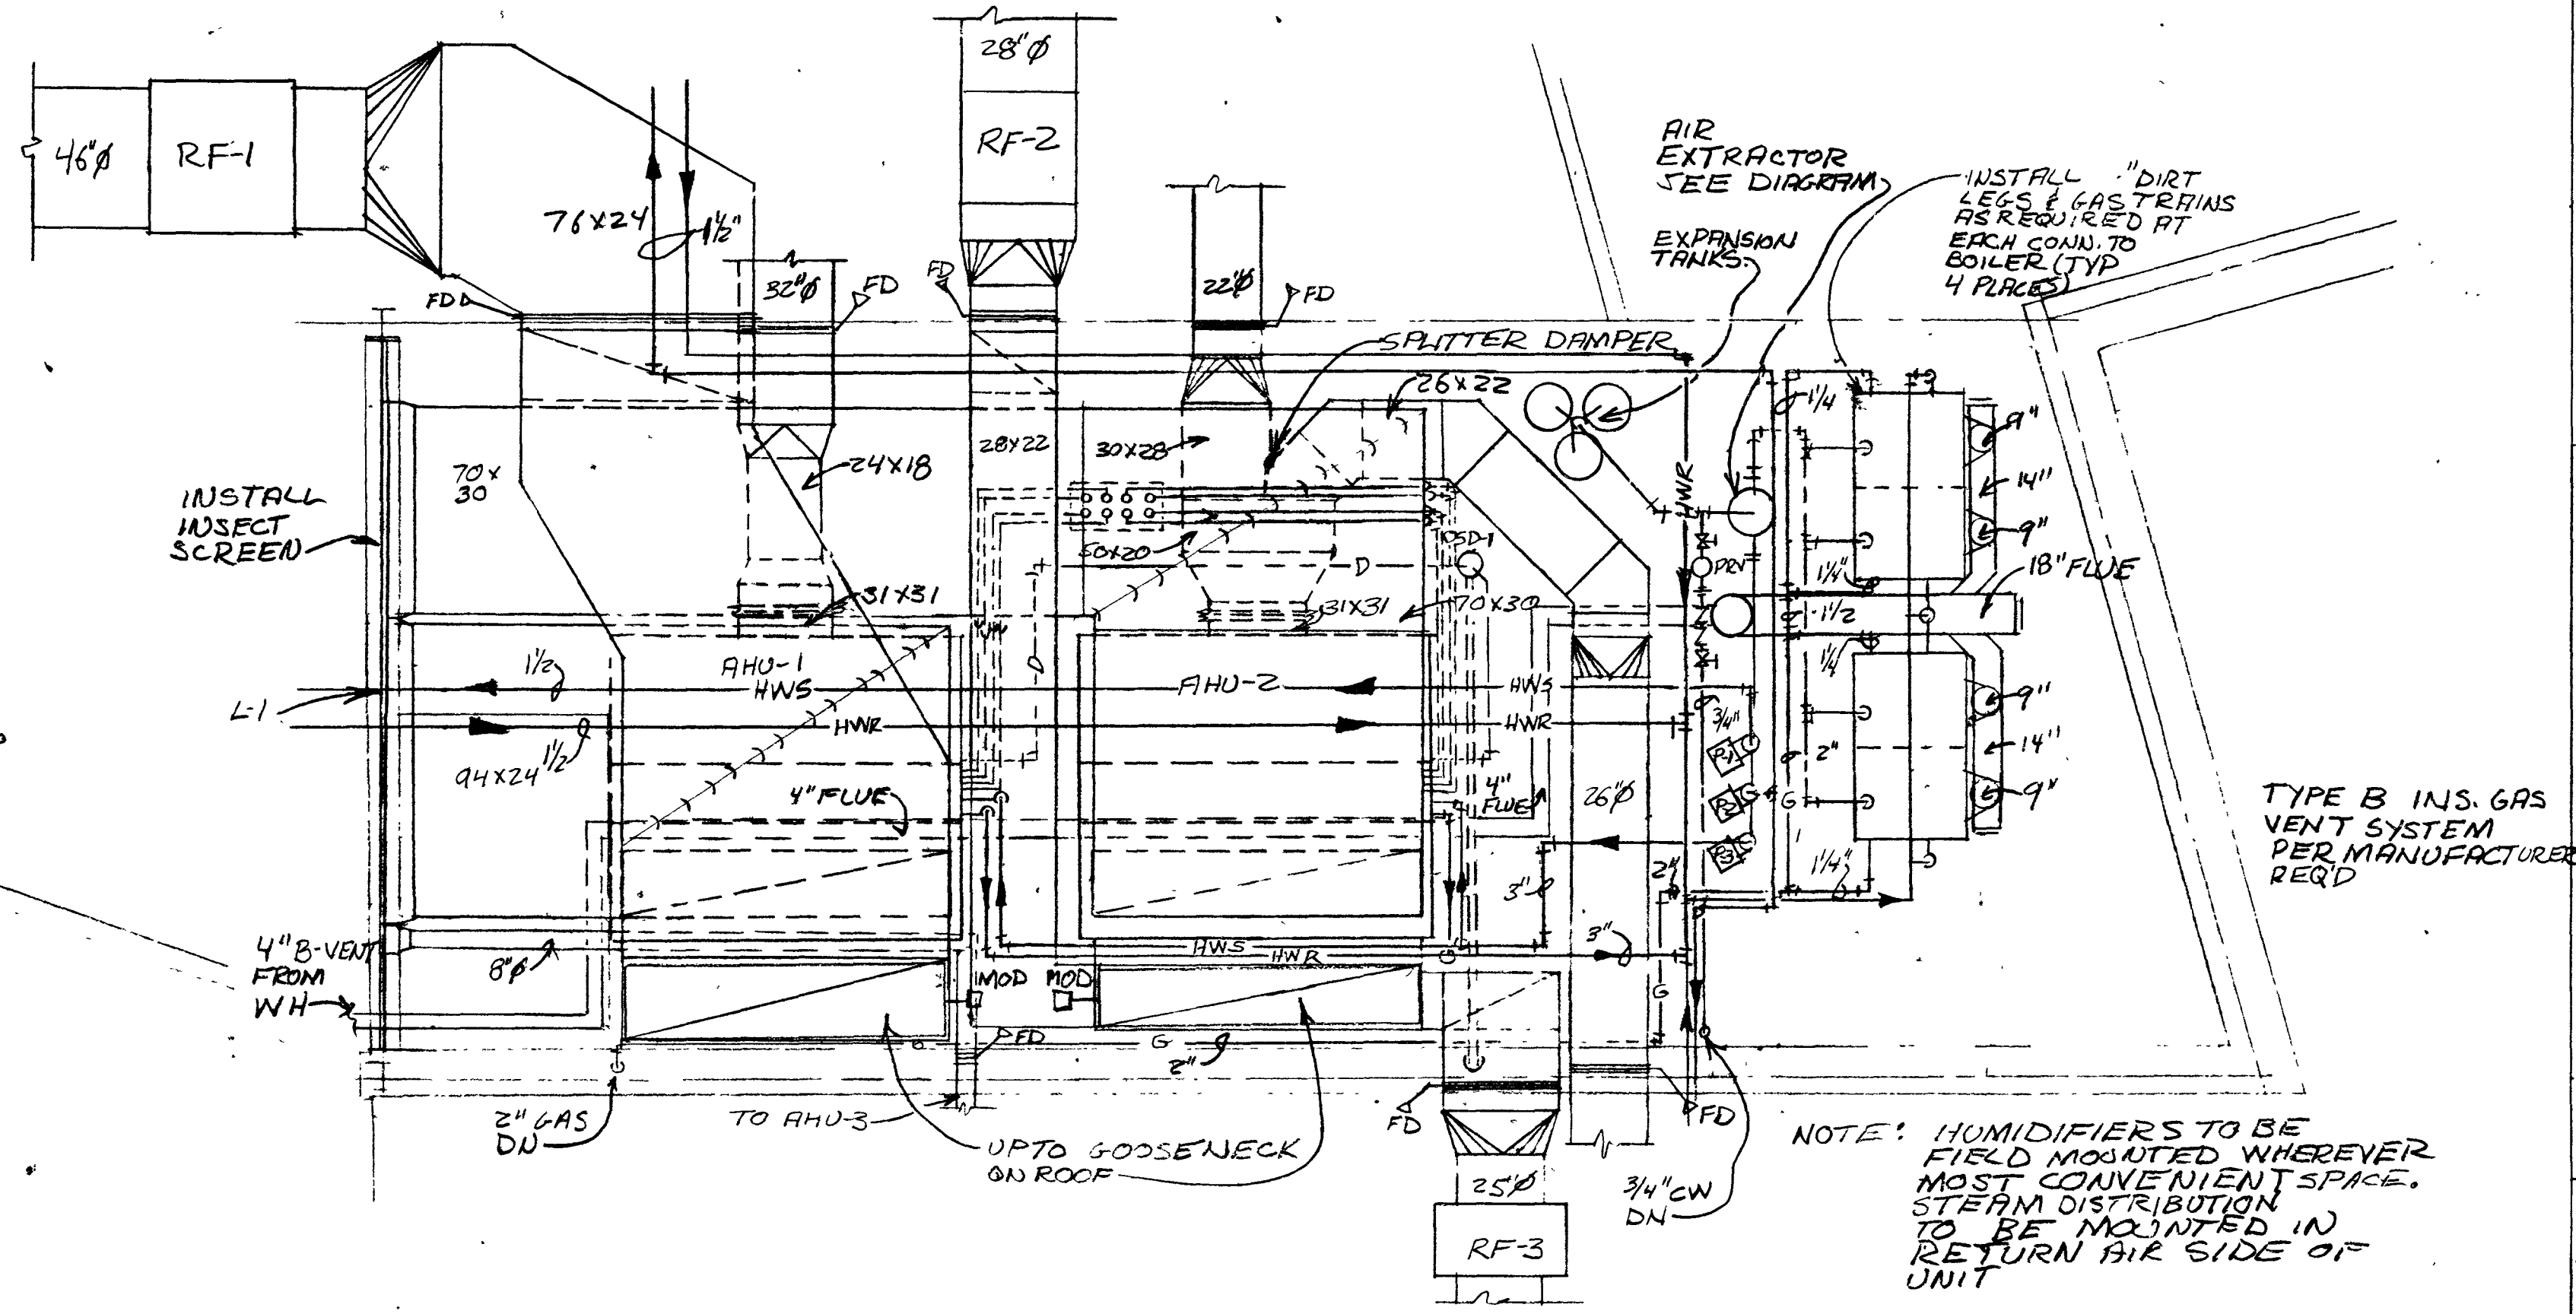

MECHANICAL ROOM PLAN SCALE 1/4"=1'-0"

**NEW FACILITY FOR
 BLUFFTON -
 WELLS COUNTY
 PUBLIC LIBRARY
 BLUFFTON, INDIANA 46714**

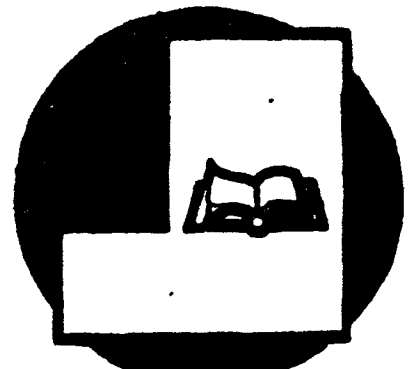

SHEET TITLE:
**MECHANICAL ROOM
 PLAN & DETAILS**

PROJECT NO. REVISIONS SHEET NO.
 DATE: **M-3**