


NOTES:

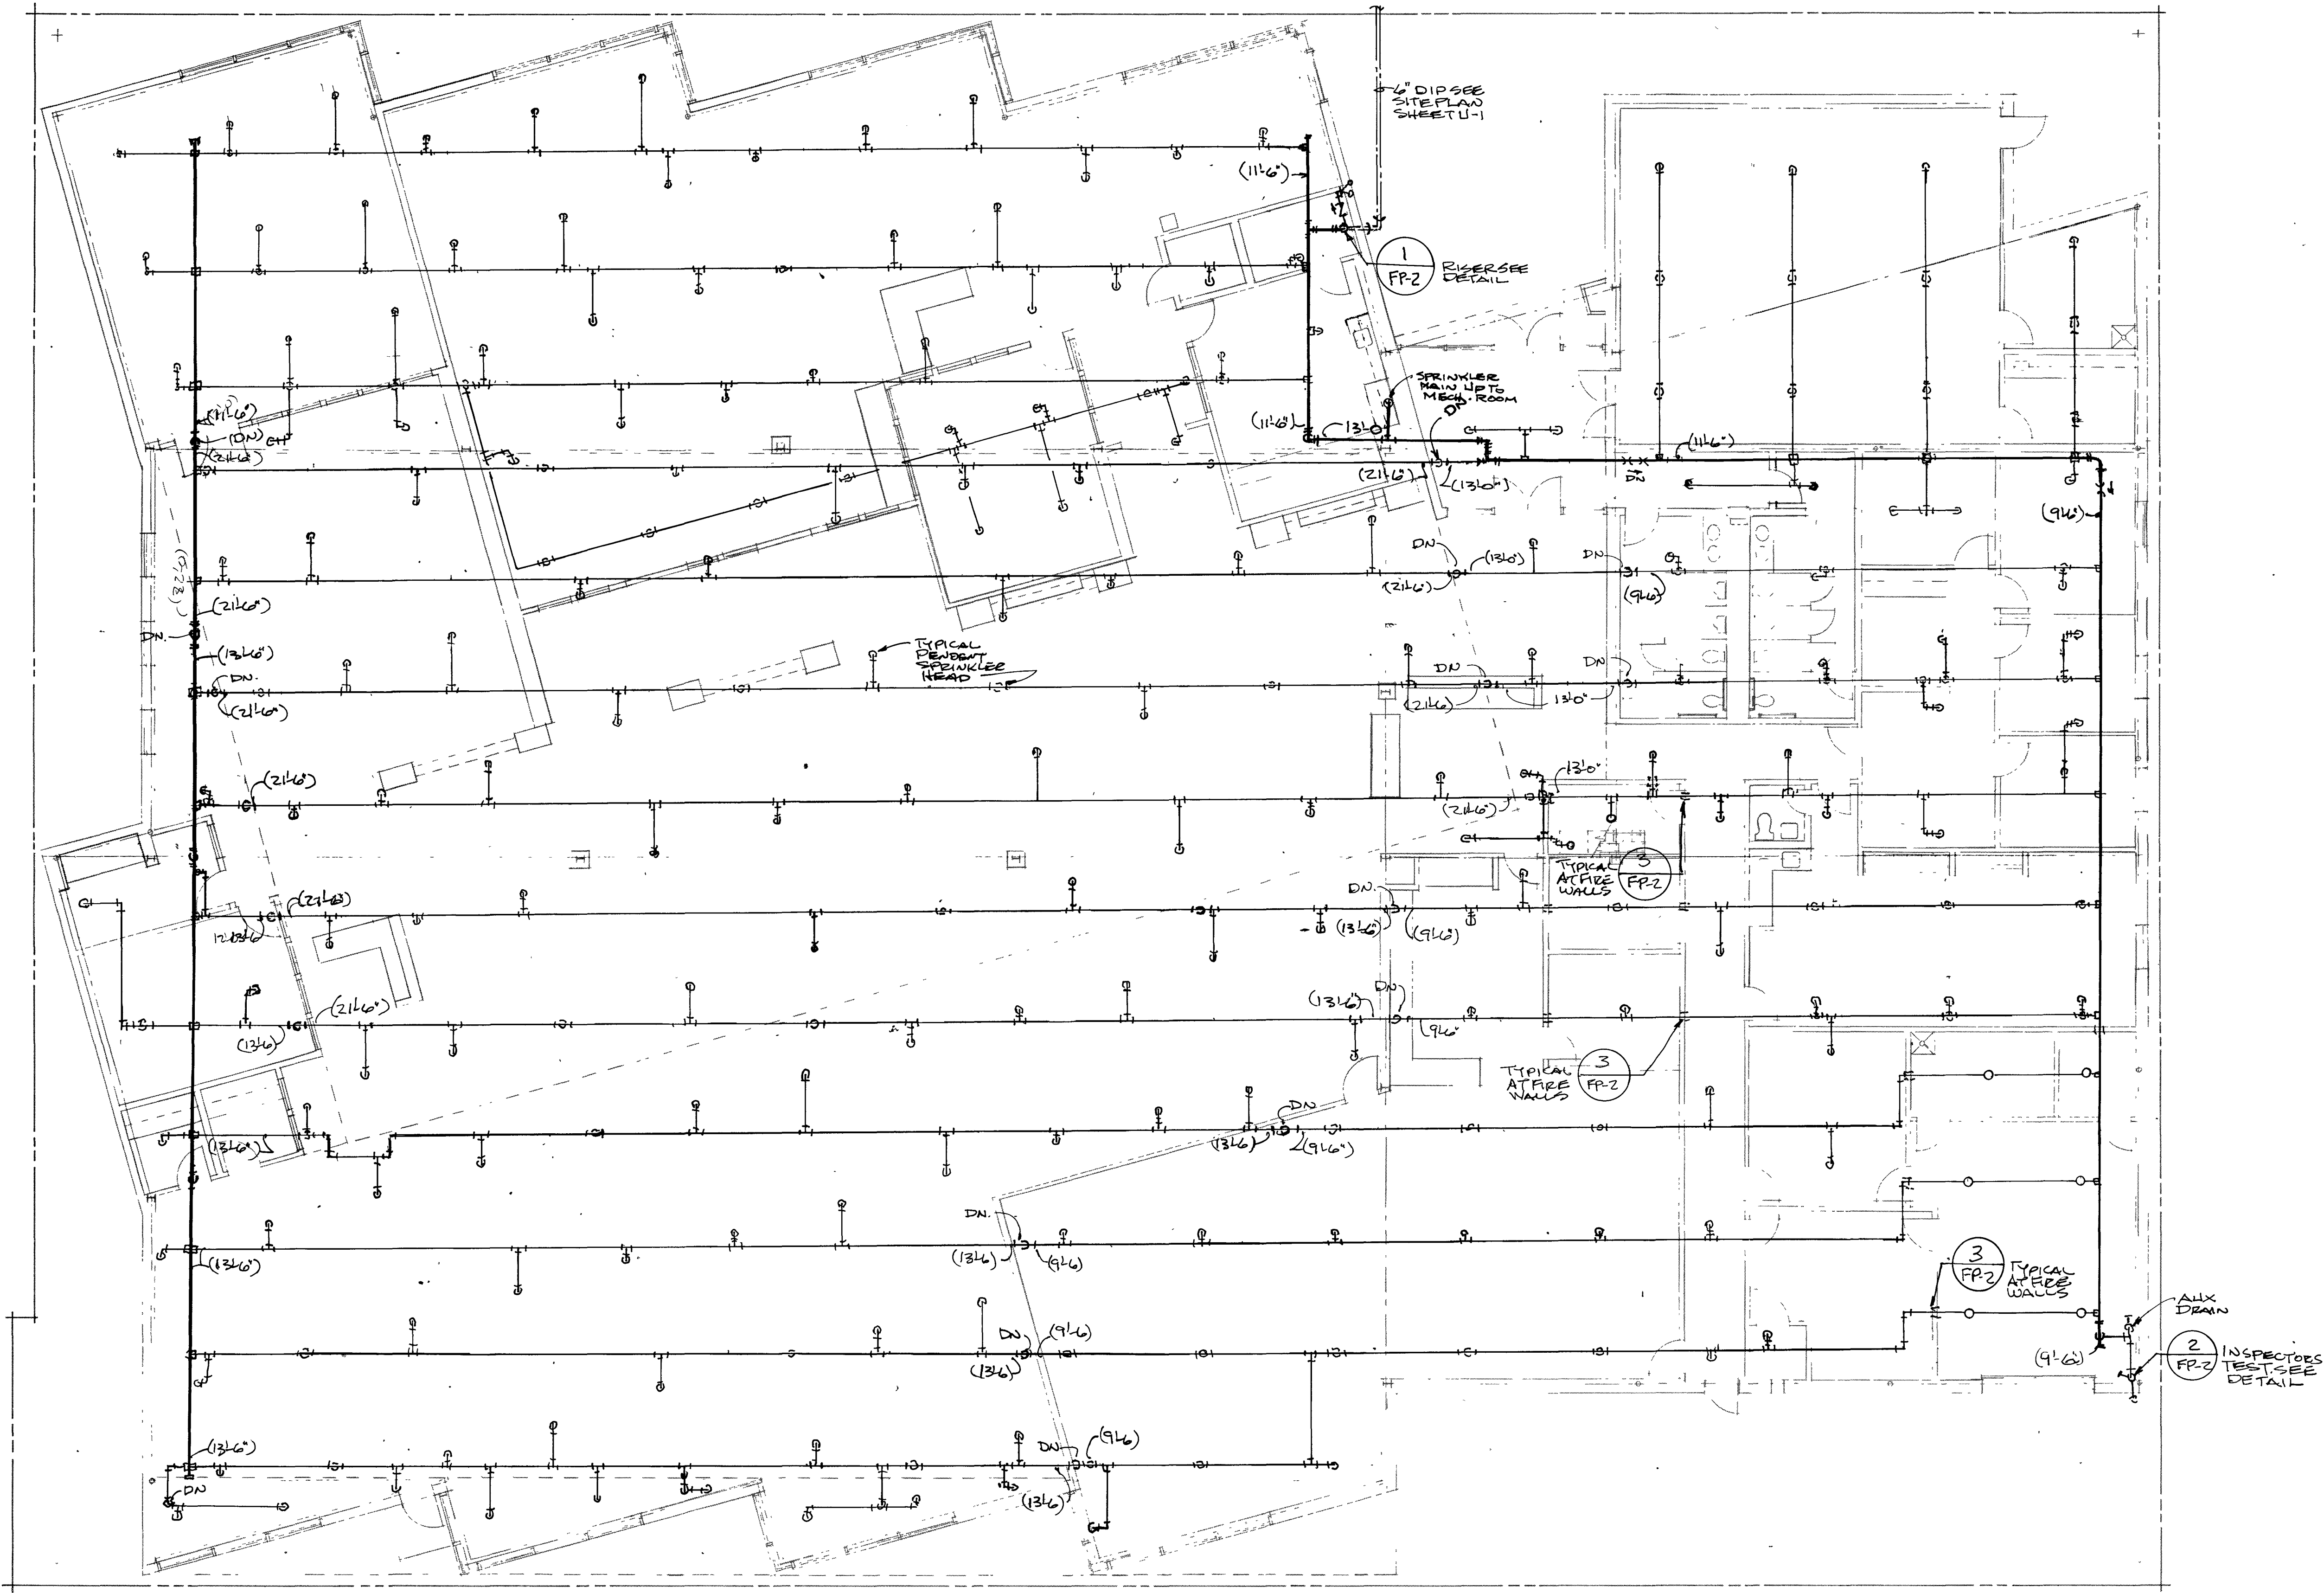


1111
5222
333
444
555
666
777
888
999
000

T 1.
B
G
a
b
c

FIRE PROTECTION PLAN
SCALE: 1/8"=1'-0"

NEW FACILITY FOR
BLUFFTON - WELLS COUNTY PUBLIC LIBRARY
BLUFFTON, INDIANA 46714

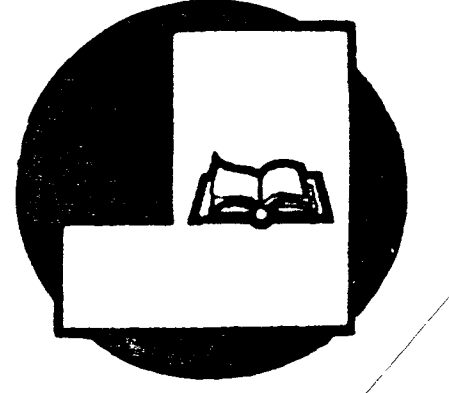

SHEET TITLE:
FIRE PROTECTION PLAN
PROJECT NO.
88-1207
DATE:
6-20-90