


NOTES:


1. PROVIDE TYPE FI FIXTURES UNLESS OTHERWISE NOTED

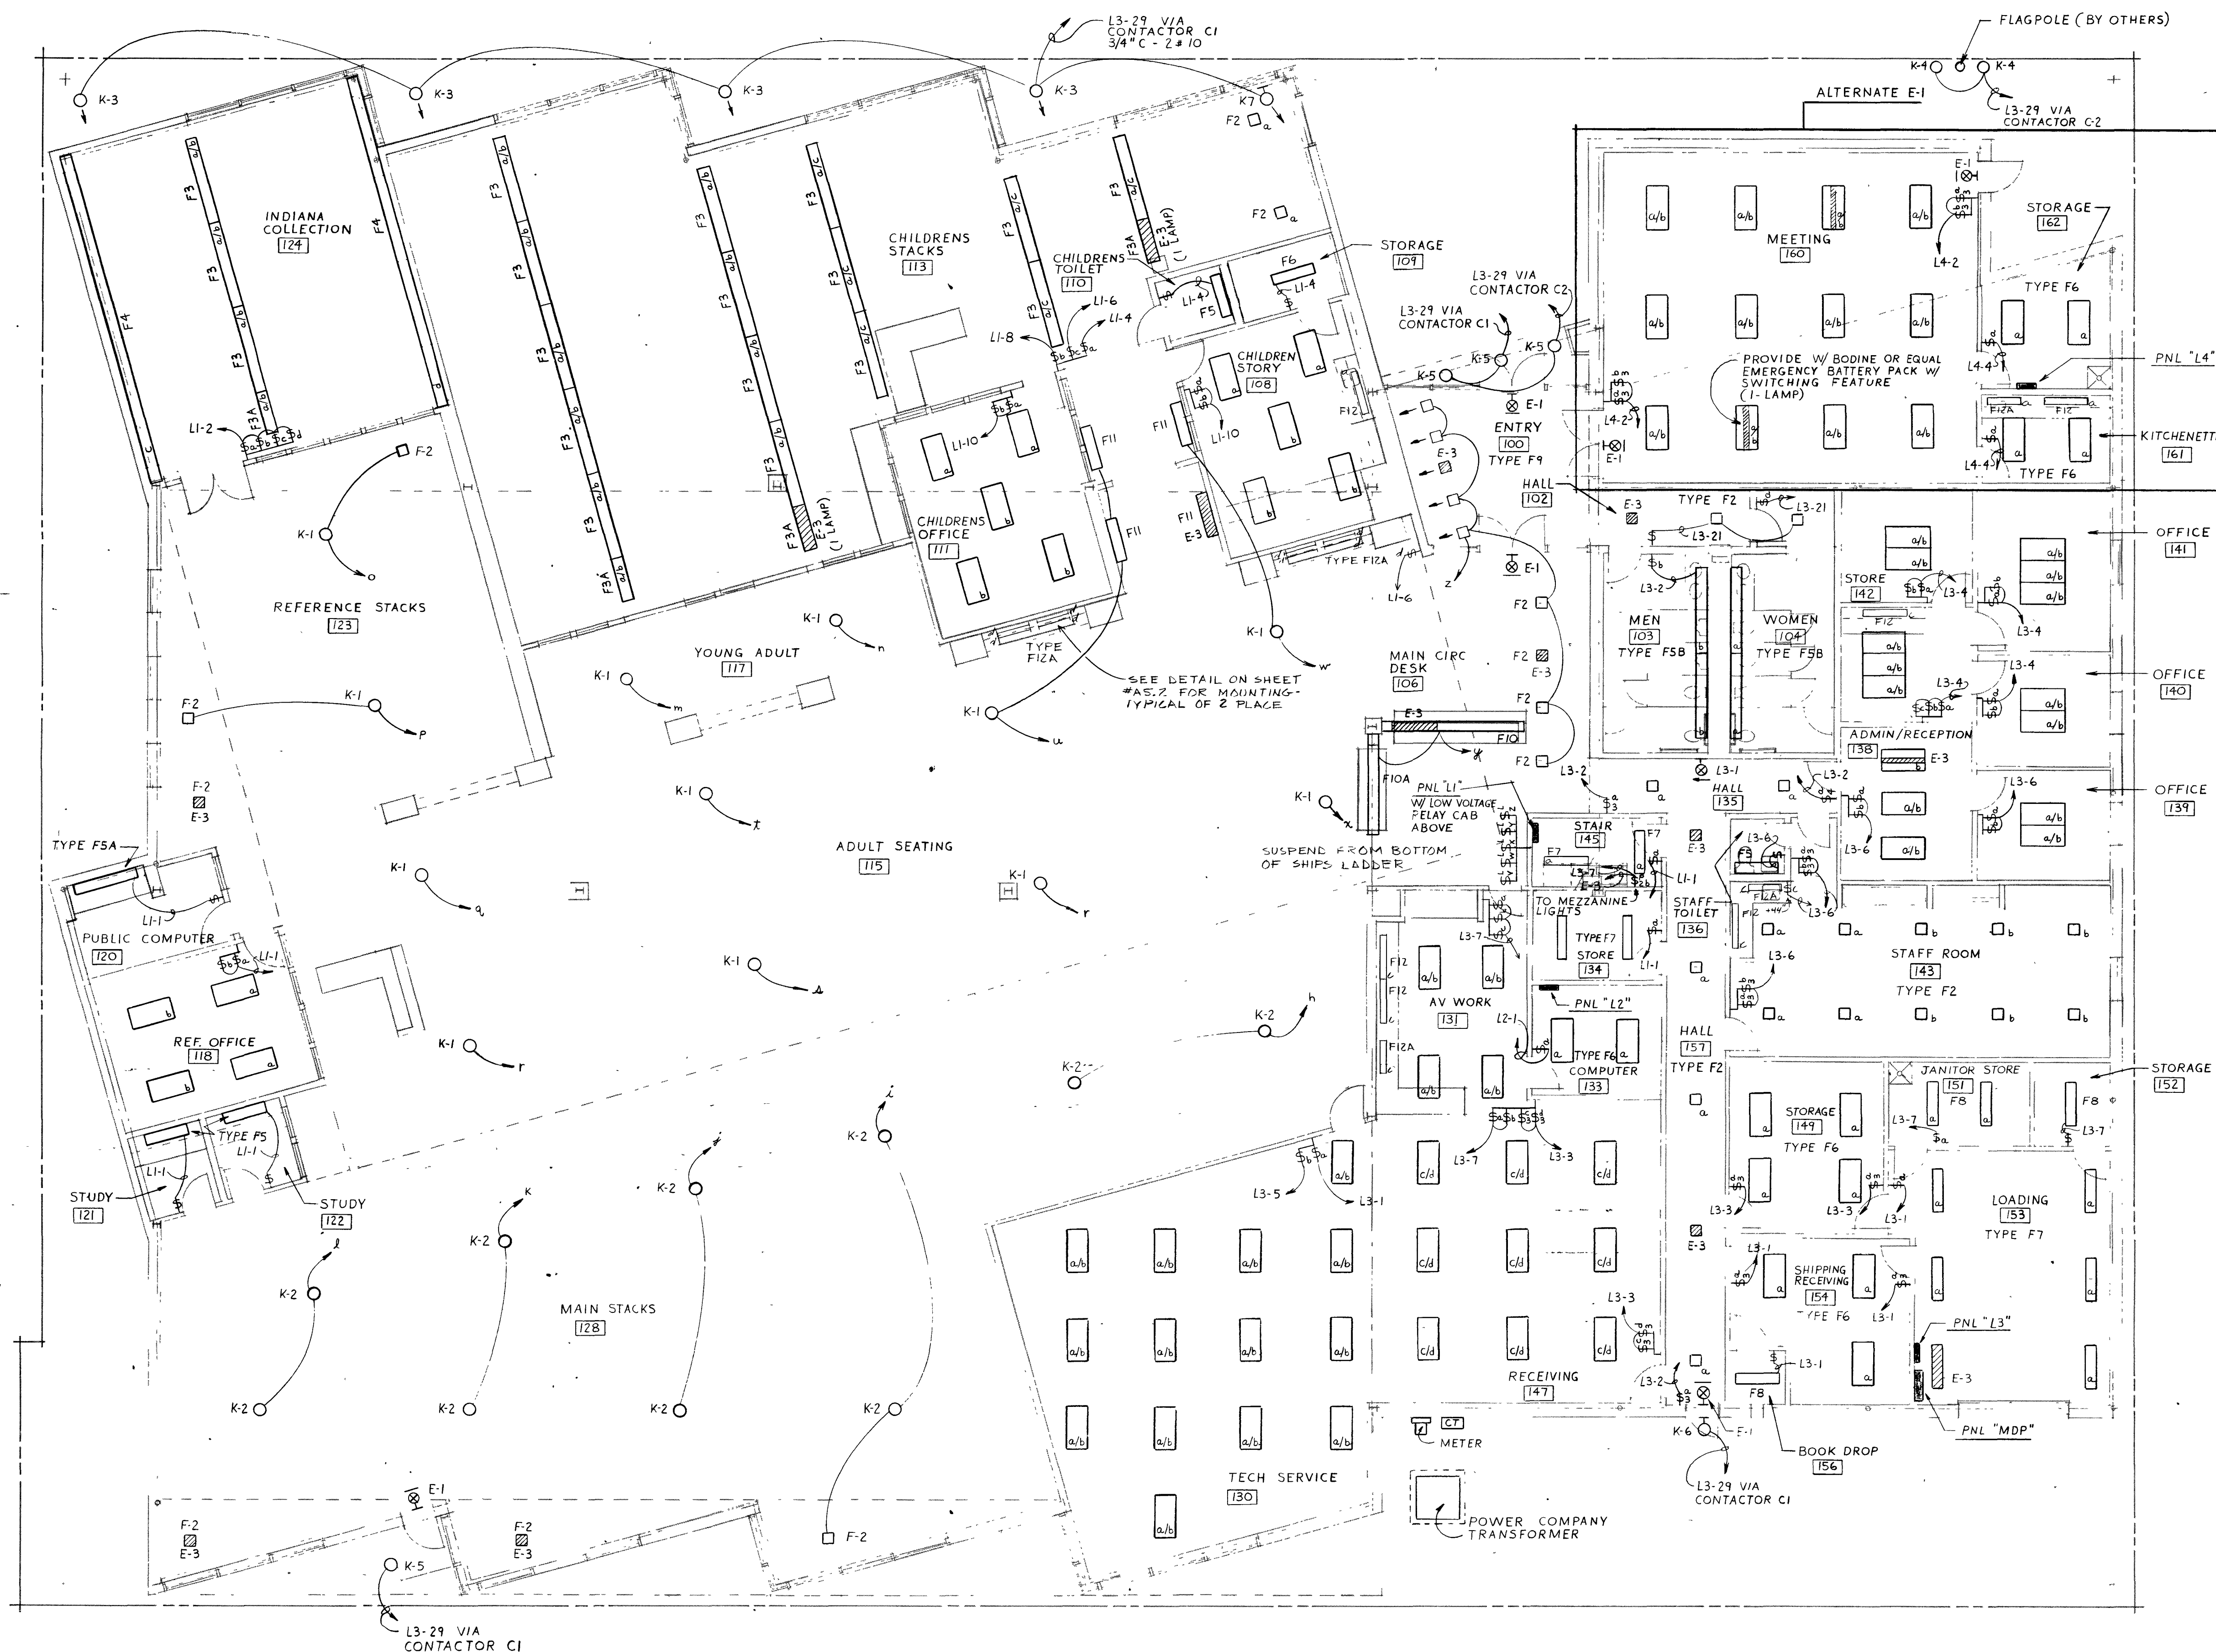

1111
5222
333
444
555
666
777
888
999
000

T. I.
B
G
a
b
c

**NEW FACILITY FOR
BLUFFTON -
WELLS COUNTY
PUBLIC LIBRARY
BLUFFTON, INDIANA 46**

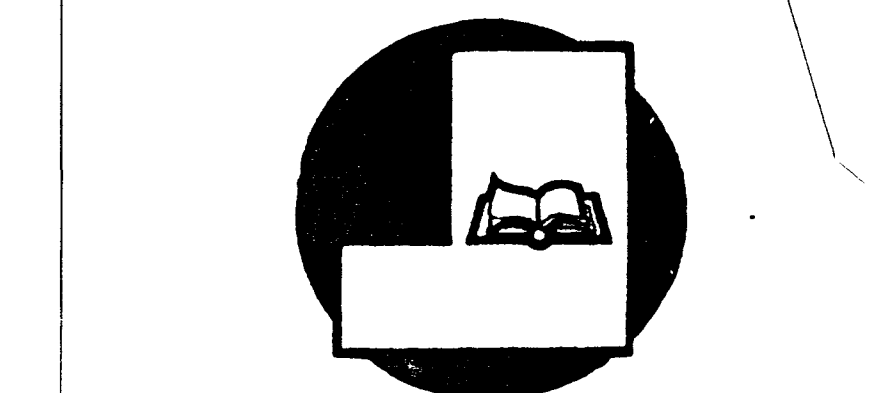

SHEET TITLE :
LIGHTING PLAN

PROJECT NO. 88-1207
REVISIONS :
DATE : 6-20-90

SHEET NO. **E-1**

LIGHTING PLAN
SCALE: 1/8"=1'-0"

