



- NOTES:**
- CONNECT RACEWAY TO BOTH DATA & POWER PANELS.
 - TCC - TEMPERATURE CONTROL CONTACTS.
 - CONNECT BLOCK HTR. & BATTERY CHARGER AS REQD.

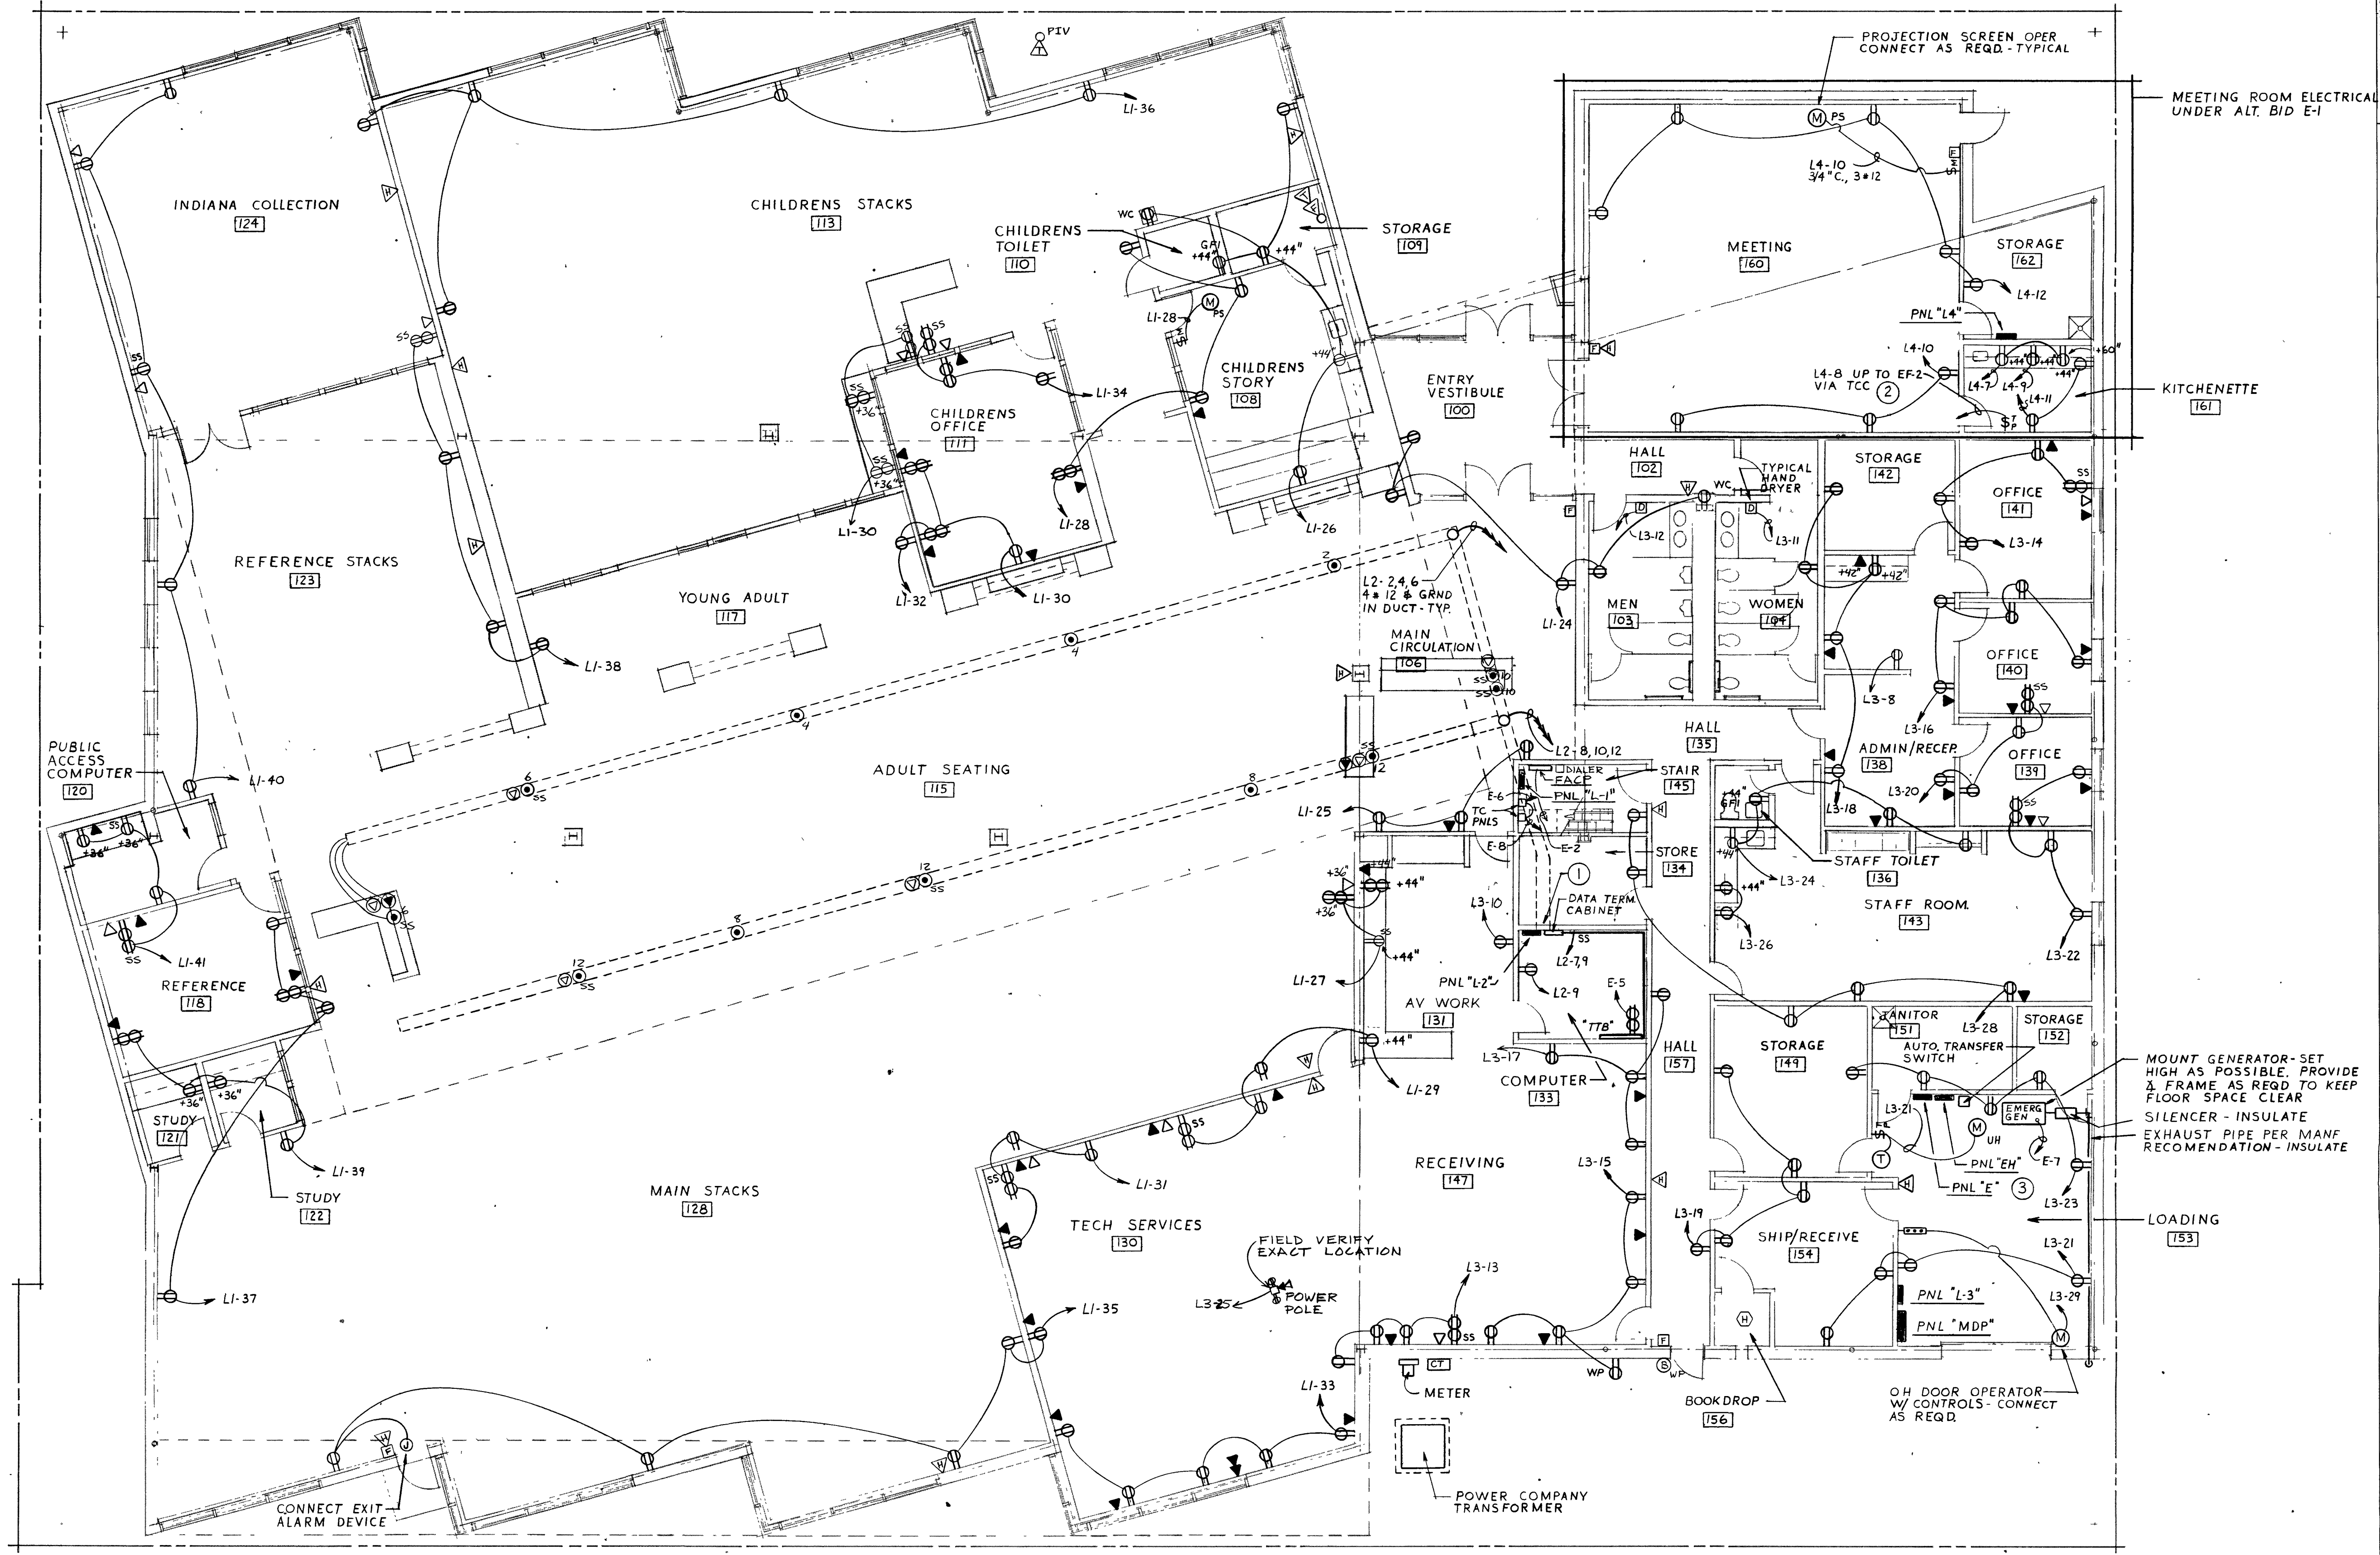

MOUNT GENERATOR - SET HIGH AS POSSIBLE. PROVIDE 2" FRAME AS REQD TO KEEP FLOOR SPACE CLEAR.
SILENCER - INSULATE EXHAUST PIPE PER MANF RECOMMENDATION - INSULATE

**NEW FACILITY FOR
BLUFFTON -
WELLS COUNTY
PUBLIC LIBRARY
BLUFFTON, INDIANA 46714**

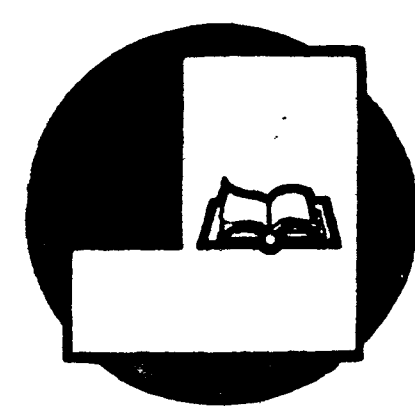

SHEET TITLE :

POWER PLAN

PROJECT NO. 88-1207	REVISIONS :	SHEET NO. E-2
DATE : 6-20-90		

1111
5222
333
444
555
666
777
888
999
000

T 1,
B
G
a
b
c

POWER PLAN
SCALE: 1/8"=1'-0"

