



CERTIFICATION



*Eric W. Sank*

All concepts, ideas, designs, plans and details on this document are the sole property of Design Collaborative, Inc. and shall not be used for any purpose without their expressed written consent. The owner shall be permitted to reach copies for information and reference.

**Wells County Public Library**  
200 West Washington Street  
Bluffton, Indiana 46714




REVISION      DATE      BY


DATE      PROJECT  
11/2/2005      2005.0039

TITLE  
Second Floor and Mezzanine Power Plans

SHEET  
**E1.2**

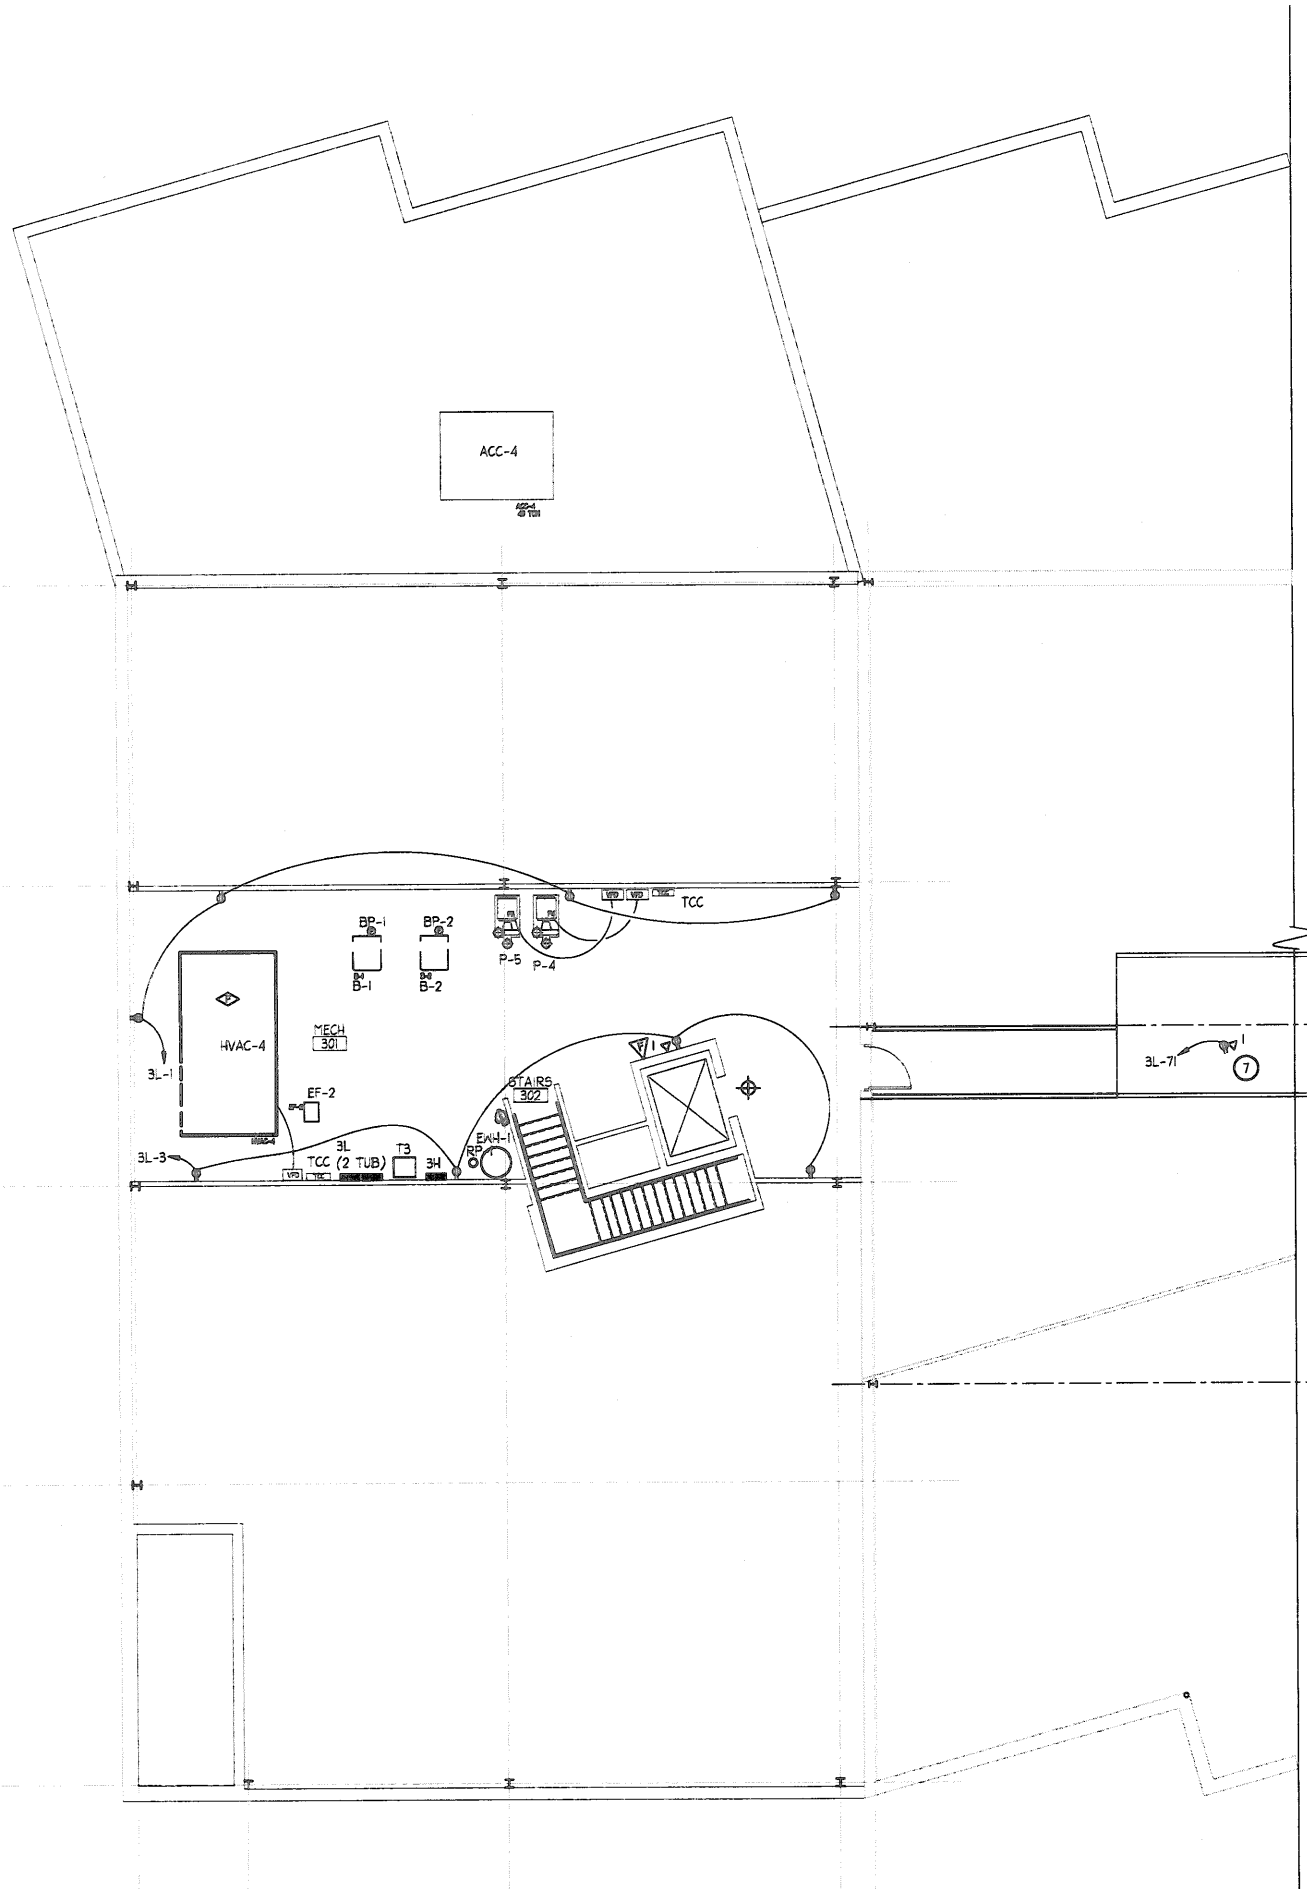

**MEZZANINE POWER PLAN**  
SCALE: 1/8" = 1'-0"  
NORTH

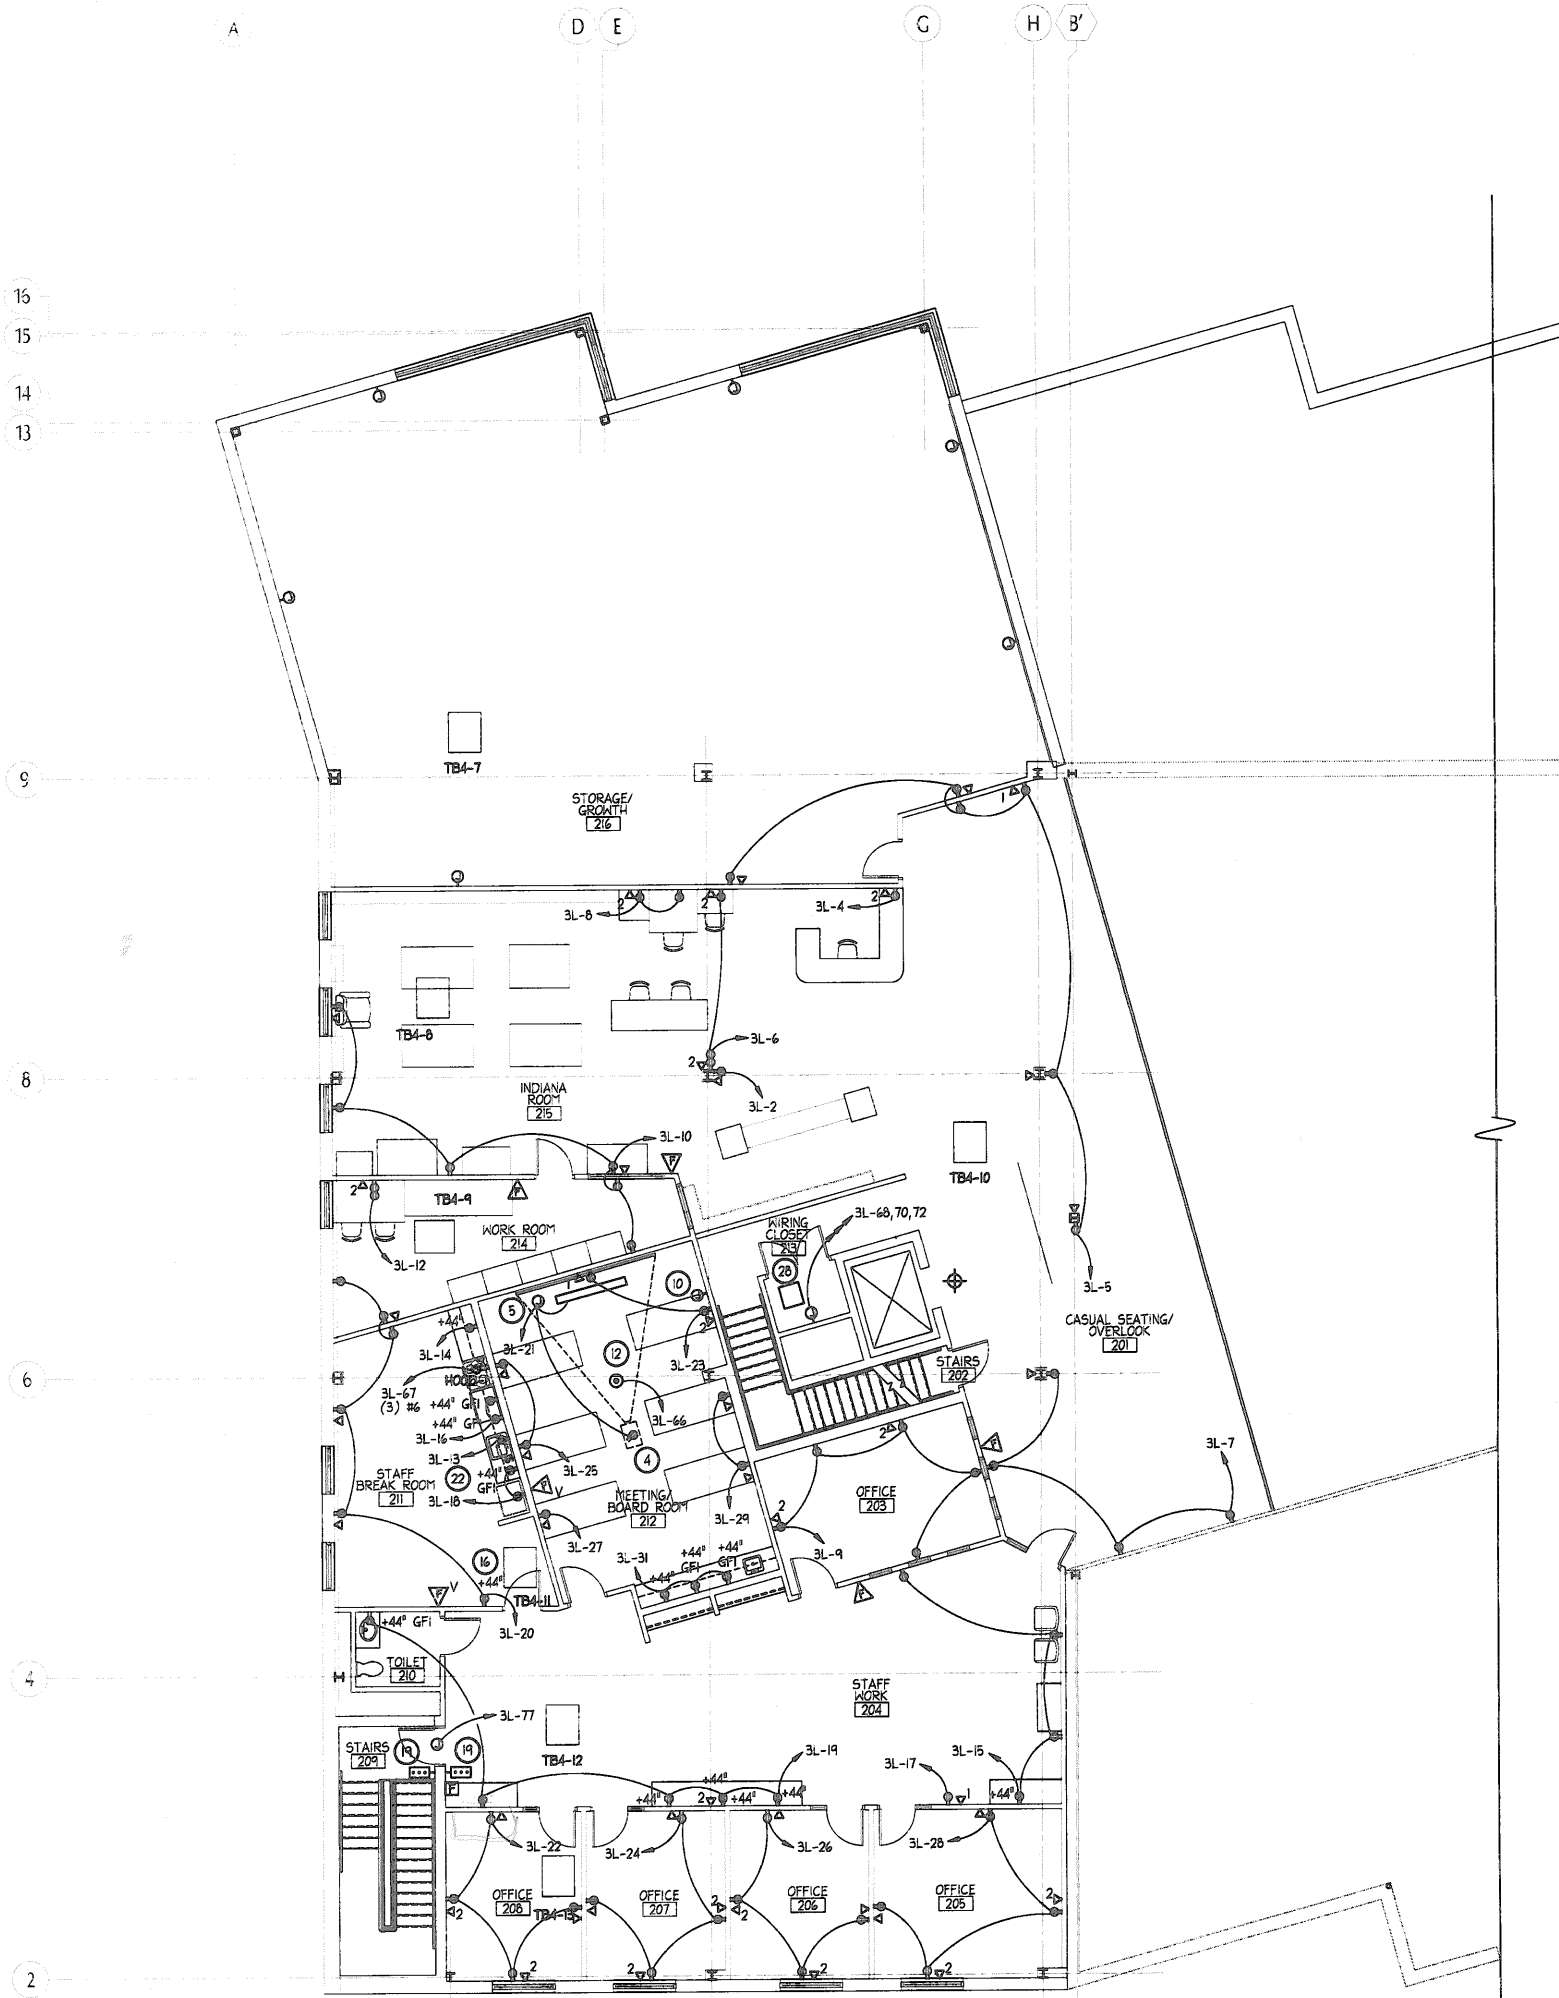

**SECOND FLOOR POWER PLAN**  
SCALE: 1/8" = 1'-0"  
NORTH