



NOTES:

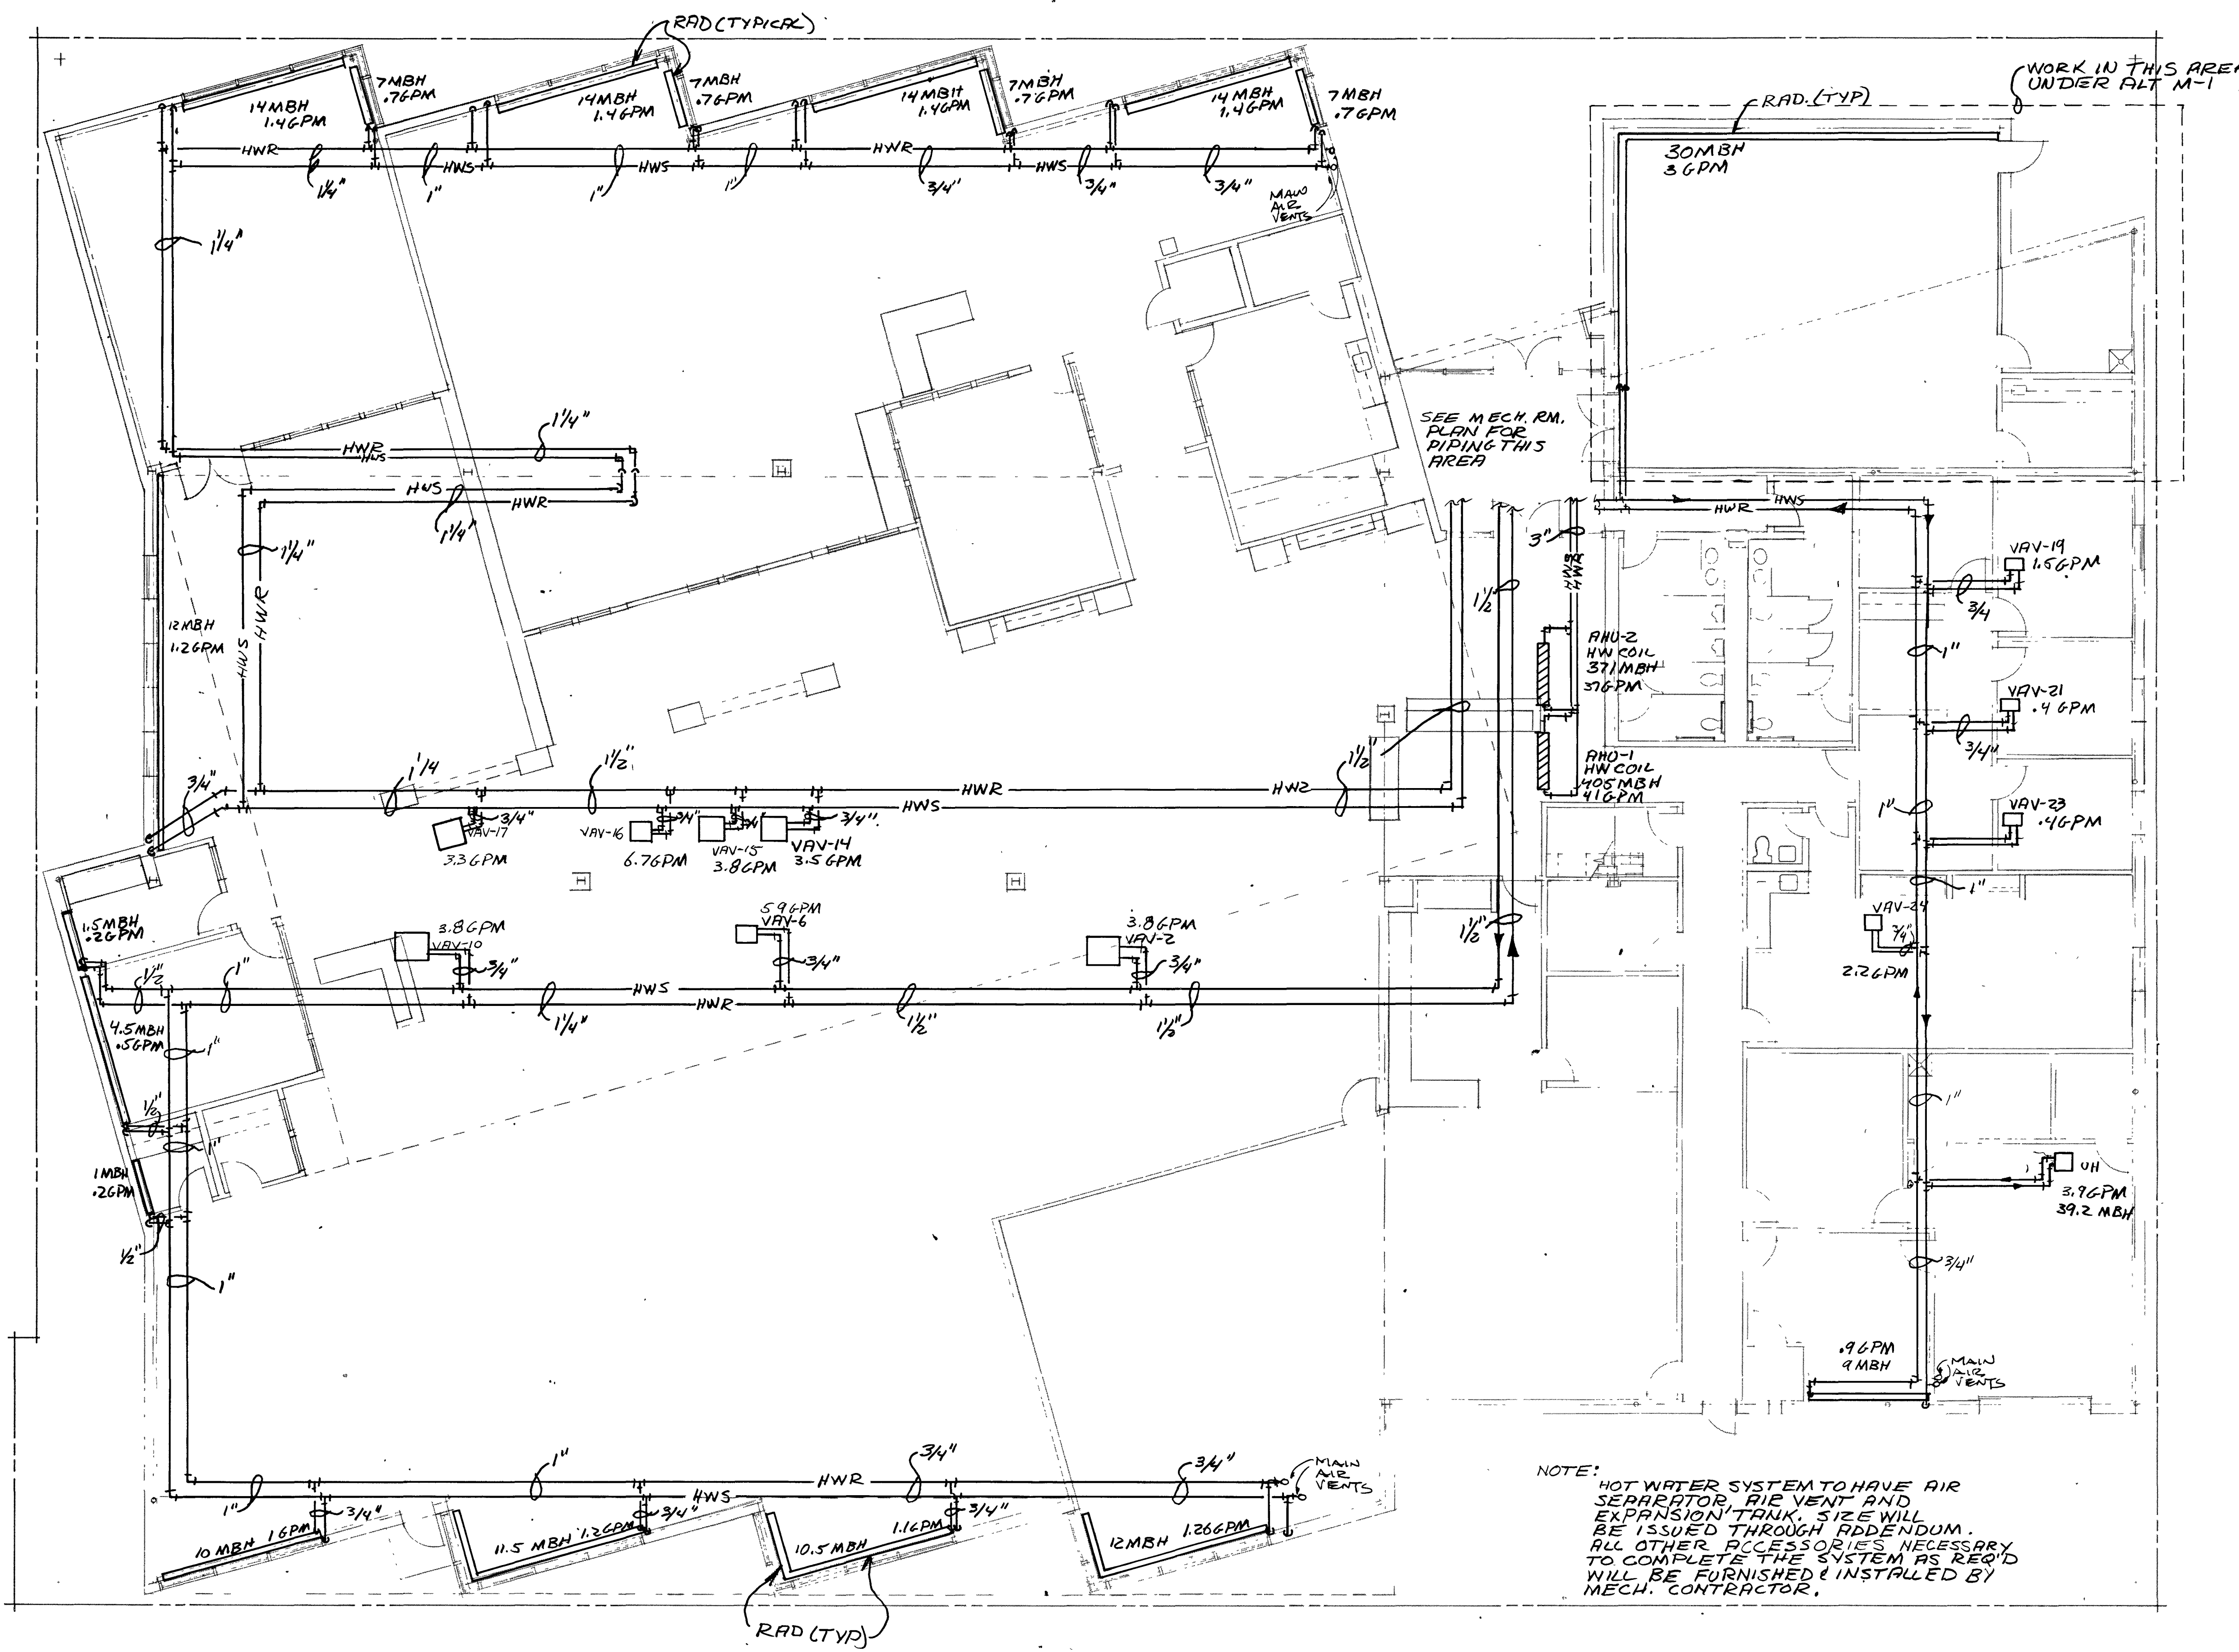

NOTE:
HOT WATER SYSTEM TO HAVE AIR SEPARATOR, AIR VENT AND EXPANSION TANK. SIZE WILL BE ISSUED THROUGH ADDENDUM. ALL OTHER ACCESSORIES NECESSARY TO COMPLETE THE SYSTEM AS REQ'D WILL BE FURNISHED & INSTALLED BY MECH. CONTRACTOR.

NEW FACILITY FOR
BLUFFTON - WELLS COUNTY PUBLIC LIBRARY
BLUFFTON, INDIANA 46714

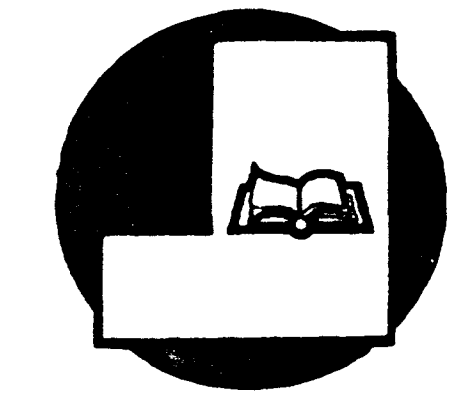

SHEET TITLE:
MECHANICAL PIPING PLAN

PROJECT NO. 88-1207	REVISIONS :	SHEET NO. M-2
DATE: 6-20-90		

MECHANICAL PIPING PLAN SCALE 1/8"=1'-0"

1111
5222
333
444
555
666
777
888
999
000

T 1
B
G
a
b
c